



Install the posts:

1. sealed and fixed with glass glue in advance before fix the posts
2. Put the posts on the right position
3. Use 5 pcs M12*25 bolts to fix the posts, but do NOT tighten them before the roof installed so that can be adjusted afterwise

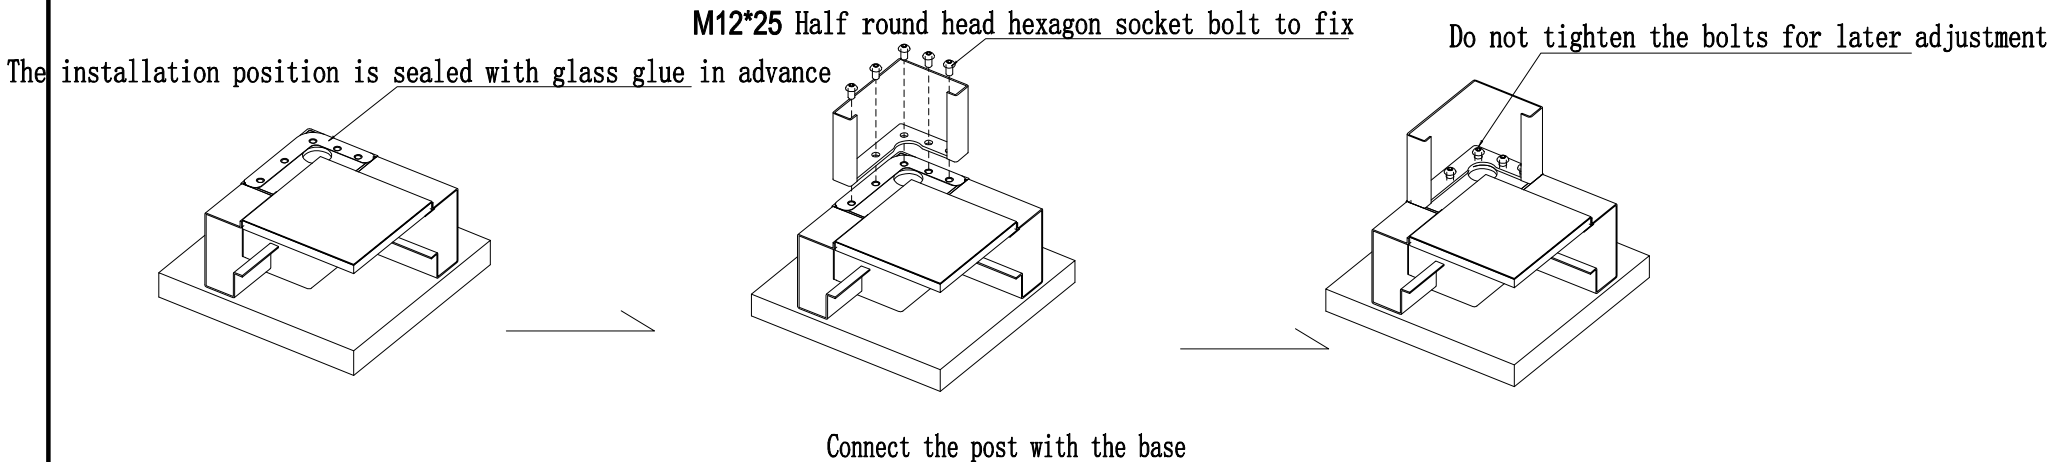

Copyright 2016.
This drawing remains the property of Hangzhou xidi Buildings Co.,Ltd.
It may only be used for the purpose for which it was commissioned &
in accordance with the terms of engagement for that commission.
Unauthorized use of this drawing is prohibited.

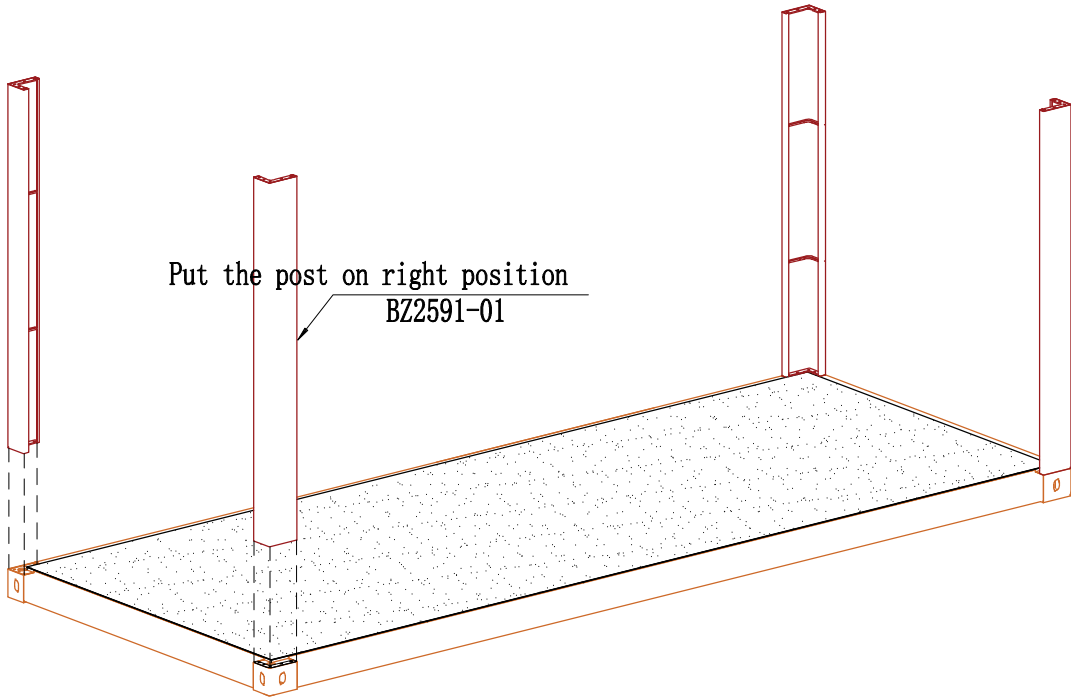

CUSTOMIZED BUILDINGS
Hangzhou Xixi Building Co., LTD
Mr. Cancan Kang
Cell Phone & WhatsApp & Viber: 008613757163354
QQ & WeChat: 66048573 Email: cancangbc@qq.com
Add.: 20th Floor, Xinyi Guangchang, Xiaoshan, Hangzhou.

版本	修改内容	日期	负责人
Rev.	Description	Date	who send

证书等级

证书编号

合作设计单位
Cooperative Designer

工 序	签名	日 期
Process	Signature	Date
审 定		
Authorized By		
审 核		
Verified By		
项目负责人		
Process		
校对人		
Checked By		
设 计		
Designed By		
制 图		
Drawn By		

执业签章
Engineer Signature

出图签章
Engineer Signature

项目名称
Project Name



图 名
Title
立柱安装

工程编号	#878	专 业	JZ
Title		图号	
比例		Dwg.No.	
Scale			

未盖技术出图章 本图纸无效
This drawing is valid only after being stamped and released by the R&D

Install the roof:

1. sealed and fixed with glass glue in advance before fix the posts
2. Put the posts on the right position
3. Use 5 pcs M12*25 bolts to fix the posts, but do NOT tighten them before all bolts fit correctly so that can be adjusted afterwise
4. Tighten all the bolts for base and roof

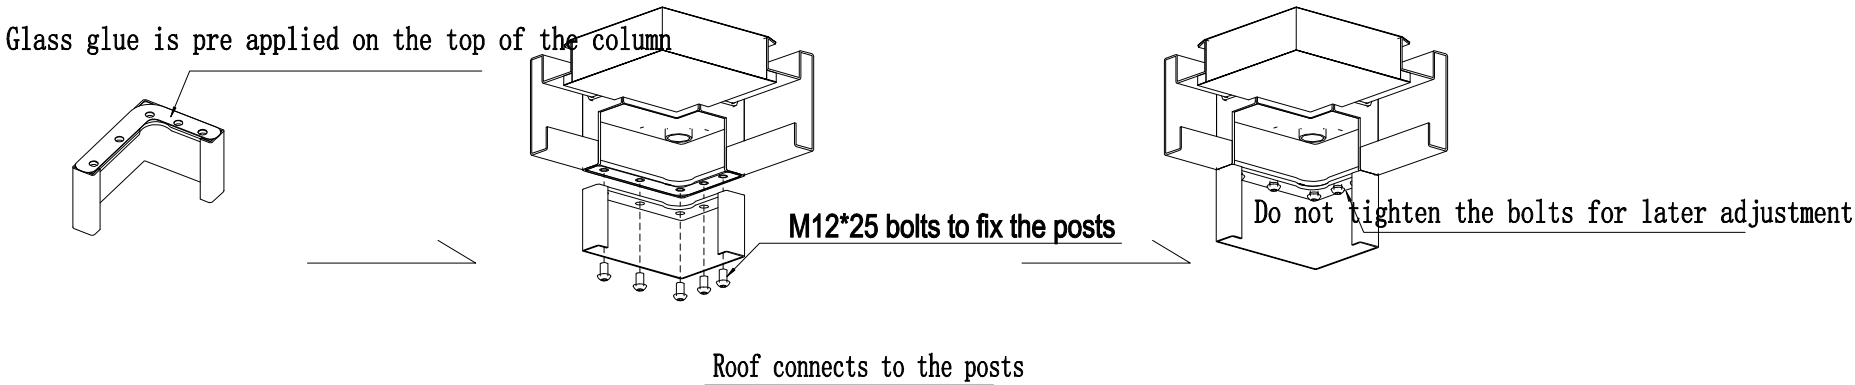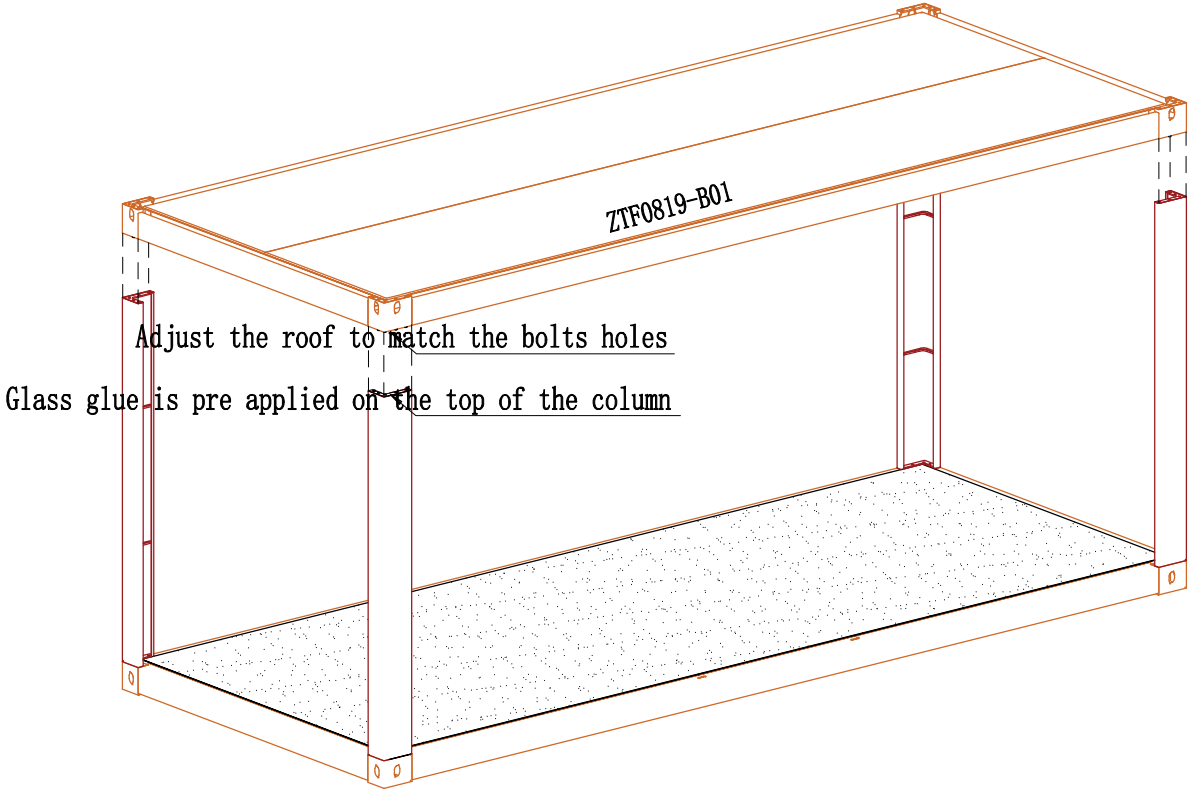

Copyright 2016.
This drawing remains the property of Hangzhou xbi Buildings Co.,Ltd.
It may only be used for the purpose for which it was commissioned &
in accordance with the terms of engagement for that commission.
Unauthorized use of this drawing is prohibited.



CUSTOMIZED BUILDINGS
Hangzhou Xixi Building Co., LTD
Mr. Cancan Kang
Cell Phone & WhatsApp & Viber: 008613757163354
QQ & WeChat: 66048573 Email: cancangbc@qq.com
Add.: 20th Floor, Xinyi Guangchang, Xiaoshan, Hangzhou,

版本 Rev.	修改内容 Description	日期 Date	负责人 who send
------------	---------------------	------------	-----------------

证书等级

证书编号

合作设计单位
Cooperative Designer

工 序 Process	签名 Signature	日 期 Date
审 定 Authorized By		
审 核 Verified By		
项目负责人 Process		
校对人 Checked By		
设 计 Designed By		
制 图 Drawn By		

执业签章
Engineer Signature

出图签章
Engineer Signature


项目名称
Project Name

图 名
Title
箱顶安装

工程编号 Title	#878	专 业 Title	JZ
比 例 Scale		图号 Dwg.No.	
未 盖 技 术 出 图 章 本 图 纸 无 效 This drawing is valid only after being stamped and released by the R&D			

Install wall panel:

- install the short end walls then the long side walls
- The short side wall panels are aligned according to the center alignment and adjusted to the left and right sides after installation
- The long side wall panel shall be adjusted according to the position of the hanging reinforcement, so as not to affect the use of the hanging reinforcement.
- The adjusting bolts of the wallboard shall be pre tightened first, and the overall inspection and tightening shall be carried out after the wallboard is adjusted.
- Hanging reinforcement and wallboards shall be installed alternately in sequence

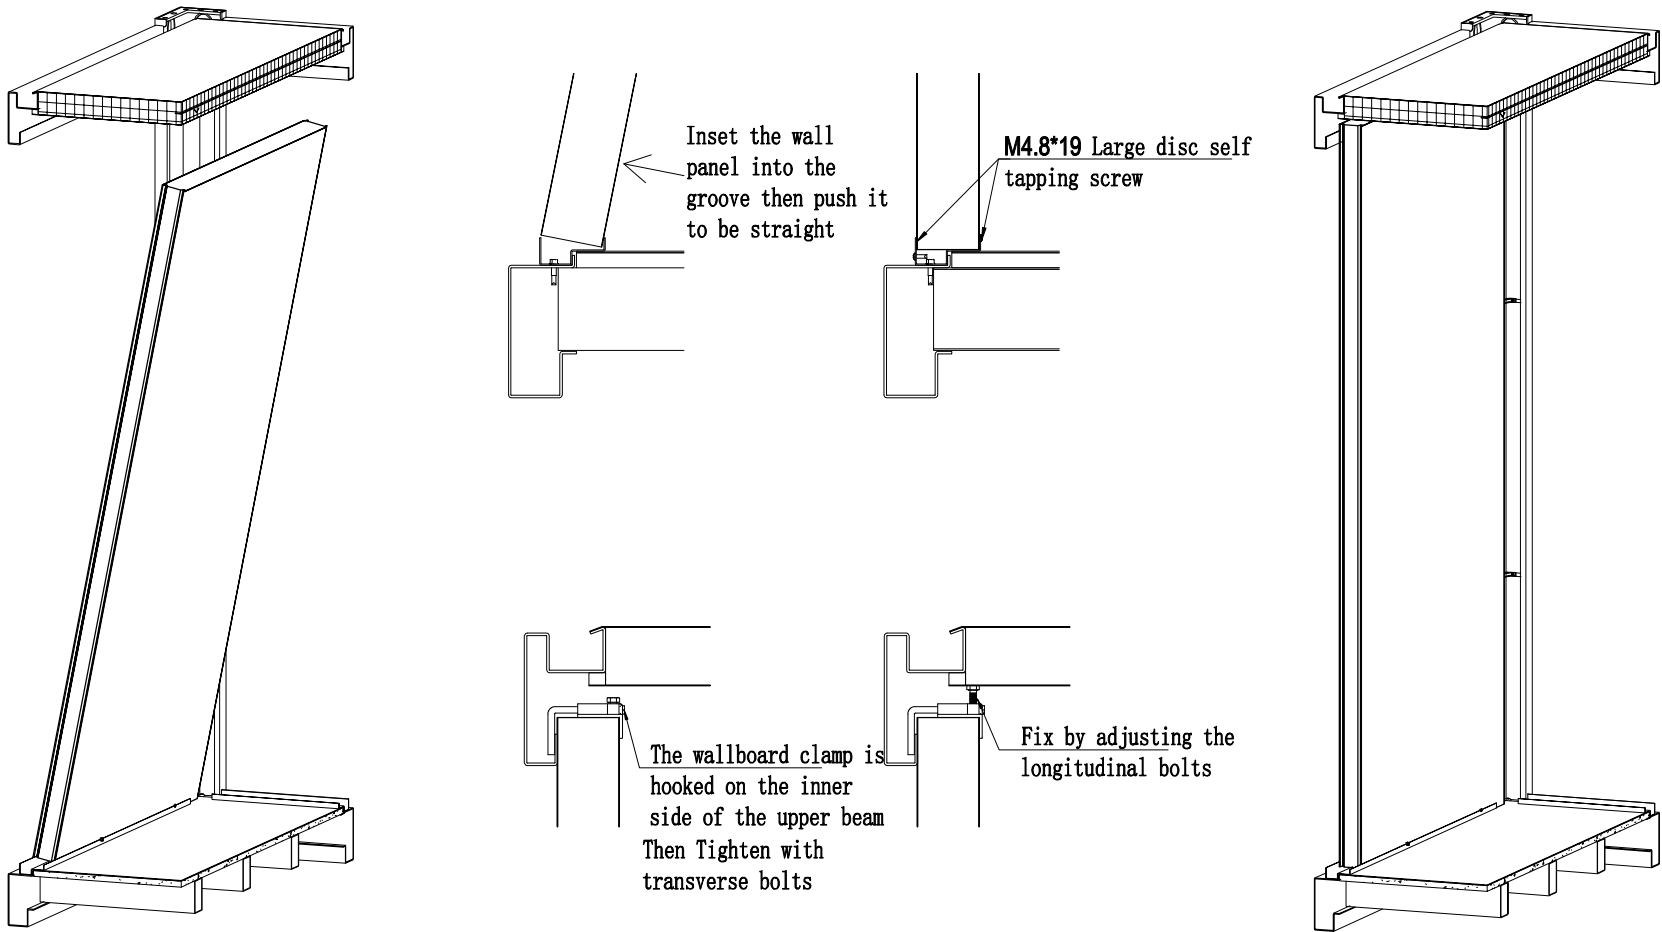

Copyright 2016.

This drawing remains the property of Hangzhou xixi Buildings Co.,Ltd. it may only be used for the purpose for which it was commissioned & in accordance with the terms of engagement for that commission. Unauthorized use of this drawing is prohibited.

CBC

CUSTOMIZED BUILDINGS

Hangzhou Xixi Building Co., LTD

Mr. Cancan Kang
Cell Phone & WhatsApp & Viber: 008613757163354
QQ & WeChat: 66048573 Email: cancangbc@qq.com
Add.: 20th Floor, Xinyi Guangchang, Xiaoshan, Hangzhou,

版本 Rev.	修改内容 Description	日期 Date	负责人 who send
------------	---------------------	------------	-----------------

证书等级

证书编号

合作设计单位
Cooperative Designer

工 序 Process	签名 Signature	日 期 Date
----------------	-----------------	-------------

审 定
Authorized By

审 核
Verified By

项目负责人
Process

校对人
Checked By

设 计
Designed By

制 图
Drawn By

执业签章
Engineer Signature

出图签章
Engineer Signature

项目名称
Project Name

图 名
Title



外Wall panel安装节点

工程编号 Title	#878	专 业 Title	JZ
---------------	------	--------------	----


比例 Scale		图号 Dwg.No.	
-------------	--	---------------	--

未盖技术出图章 本图纸无效
This drawing is valid only after being stamped and released by the R&D

会	建筑			电力	
签	结构			暖通	
	给排水			动力	

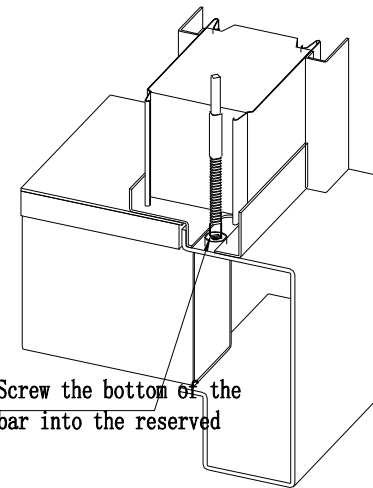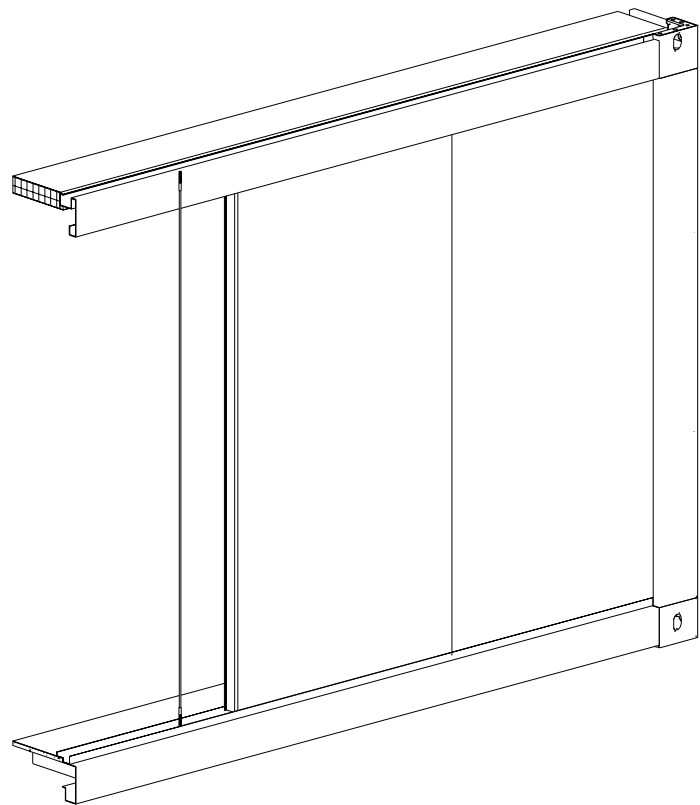

Step 1: Screw the bottom of the hanging bar into the reserved hole

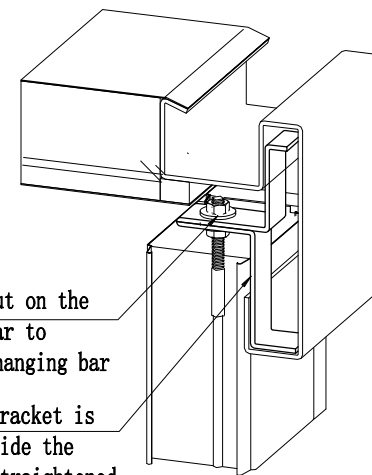

Step 3: Adjust the nut on the top of the hanging bar to tighten and fix the hanging bar

Step 2: The hanger bracket is placed obliquely inside the main beam and then straightened

Copyright 2016.

This drawing remains the property of Hangzhou Xidi Buildings Co.,Ltd, it may only be used for the purpose for which it was commissioned and in accordance with the terms of engagement for that commission. Unauthorized use of this drawing is prohibited.



Hangzhou Xidi Building Co., LTD

Mr. Cancan Kang
Cell Phone & WhatsApp & Viber: 008613757163354
QQ & WeChat: 66048573 Email: cancangbc@qq.com
Add.: 20th Floor, Xinyi Guangsheng, Xiaoshan, Hangzhou,

版本 Rev.	修改内容 Description	日期 Date	发布人 who send
------------	---------------------	------------	-----------------

证书等级	
证书编号	

合作设计单位
Cooperative Designer

工 序 Process	签名 Signature	日 期 Date
审 定 Authorized By		
审 核 Verified By		
项目负责人 Process		
校对人 Checked By		
设 计 Designed By		
制 图 Drawn By		

执业签章
Engineer Signature

出图签章
Engineer Signature

项目名称
Project Name



图名 Title	吊筋安装
-------------	------

工程编号 Title	#878	专业 Title	JZ
比例 Scale		图号 Dwg.No.	




未盖技术出图章 本图纸无效
This drawing is valid only after being stamped and released by the R&D

Install internal wall:


- 1.The last external wall panel shall not be installed first to reserve space for the internal wall panel. Before installing the inner wall panel, fix the corner aluminum on the roof with rivets according to the position of the inner wall, and then clamp the first inner wall panel in the U-shaped groove and push it to one side close to the corner aluminum and the outer wall; refer to drawings below
- 2.After the installation of the inner wall panel, install the last external wall panel, and fix the inner wall panel with the last external wall panel with angle aluminum profile, Refer to detail-B

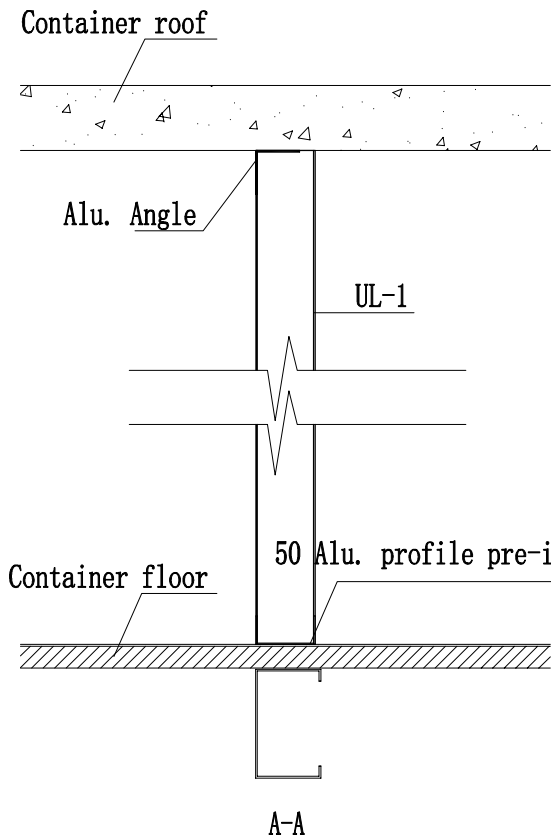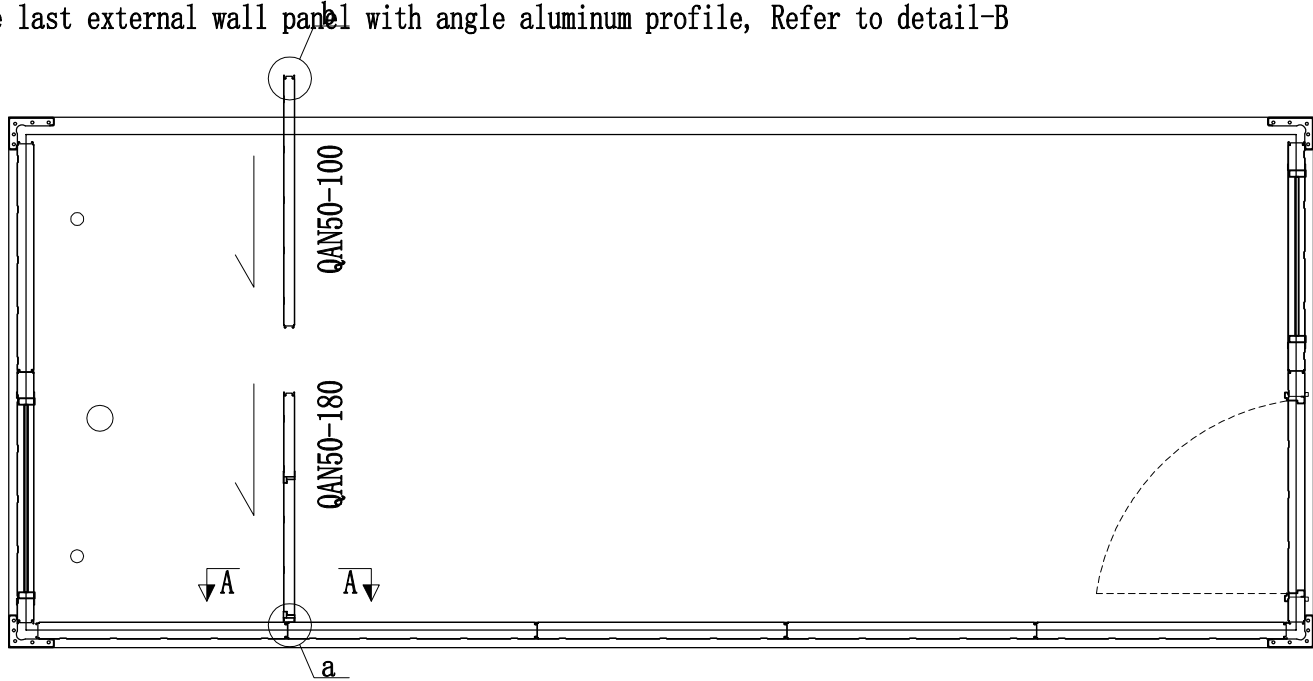

First fix the U-groove (ul-1) of the wall panel and the alu. angle to the roof. The aluminum groove at the bottom has been prefabricated in the factory

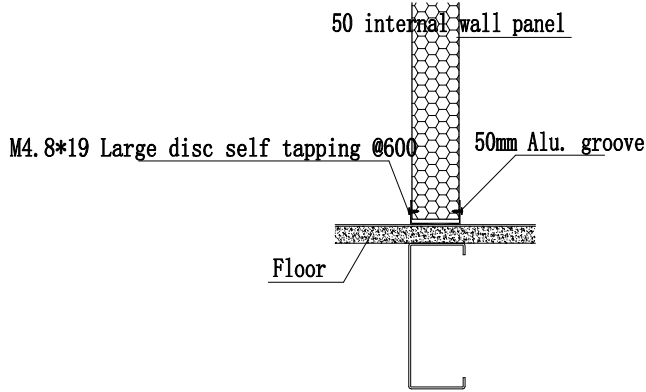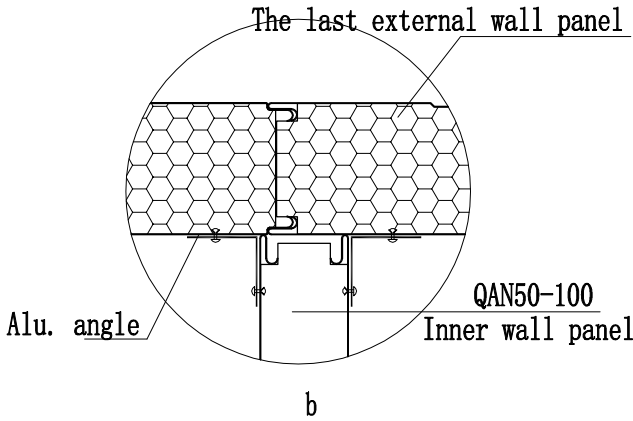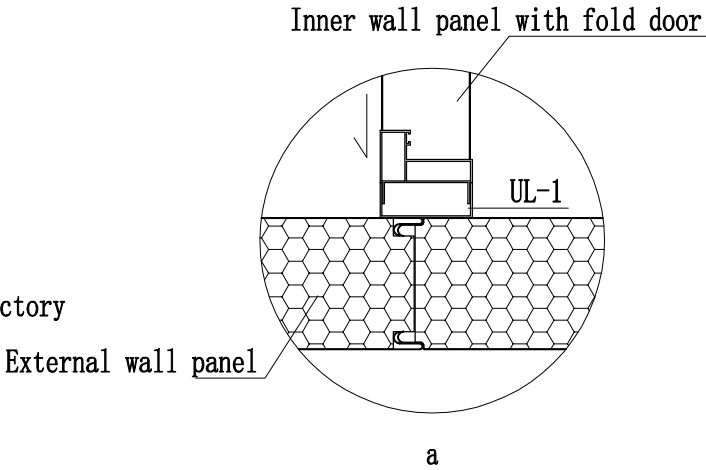

Bottom of the internal wall detail

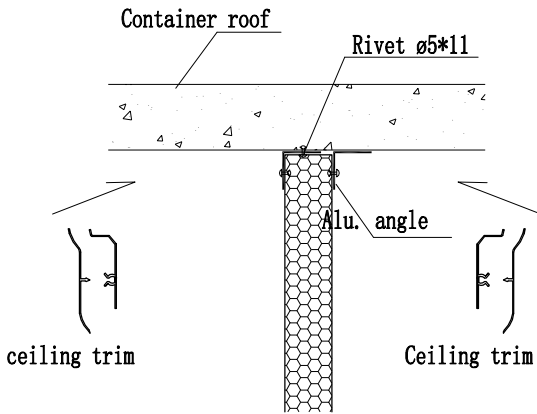

Remark: install the PVC trim after the electrical installation

Top of the internal wall installation

Copyright 2016.
This drawing remains the property of Hangzhou xixi Buildings Co.,Ltd.
It may only be used for the purpose for which it was commissioned &
in accordance with the terms of engagement for that commission.
Unauthorized use of this drawing is prohibited.

CUSTOMIZED BUILDINGS
Hangzhou Xixi Building Co., LTD
Mr. Cancan Kang
Cell Phone & WhatsApp & Viber: 008613757163354
QQ & WeChat: 66048573 Email: cancangbc@qq.com
Add.: 20th Floor, Xinyi Guangchang, Xiaoshan, Hangzhou.

Rev.	修改内容 Description	日期 Date	发布人 who send

证书等级

证书编号

合作设计单位
Cooperative Designer

工 序 Process	签名 Signature	日 期 Date
审 定 Authorized By		
审 核 Verified By		
项目负责人 Process		
校对人 Checked By		
设 计 Designed By		
制 图 Drawn By		

执业签章
Engineer Signature

出图签章
Engineer Signature

项目名称
Project Name


图 名
Title

内墙安装


工程编号 Title	#878	专 业 Title	JZ
比 例 Scale		图号 Dwg.No.	

未 盖 技 术 出 图 章 本 图 纸 无 效
This drawing is valid only after being stamped and released by the R&D


电	力	通	动	力	
建	筑	结	构	给	排
会	签				

 


Quick connect socket wire connection

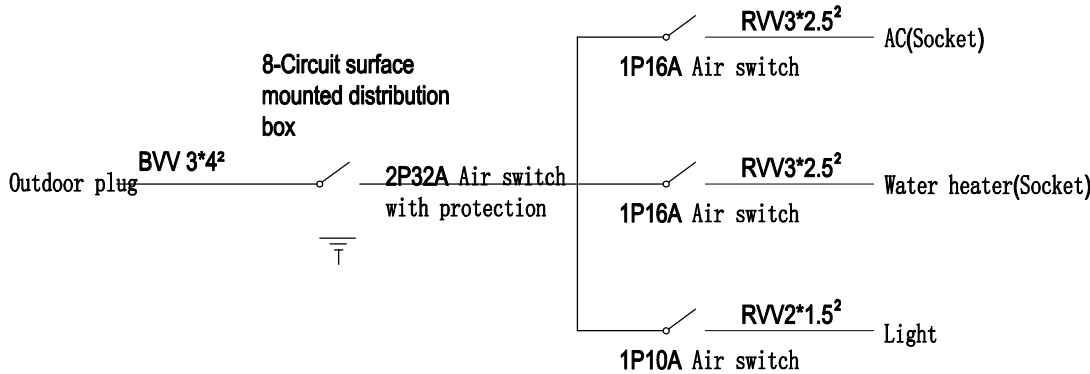


Power system layout for single unit

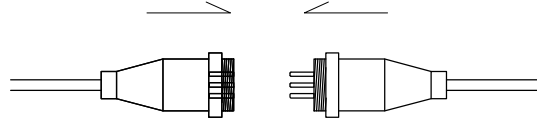

Quick connect socket wire connection

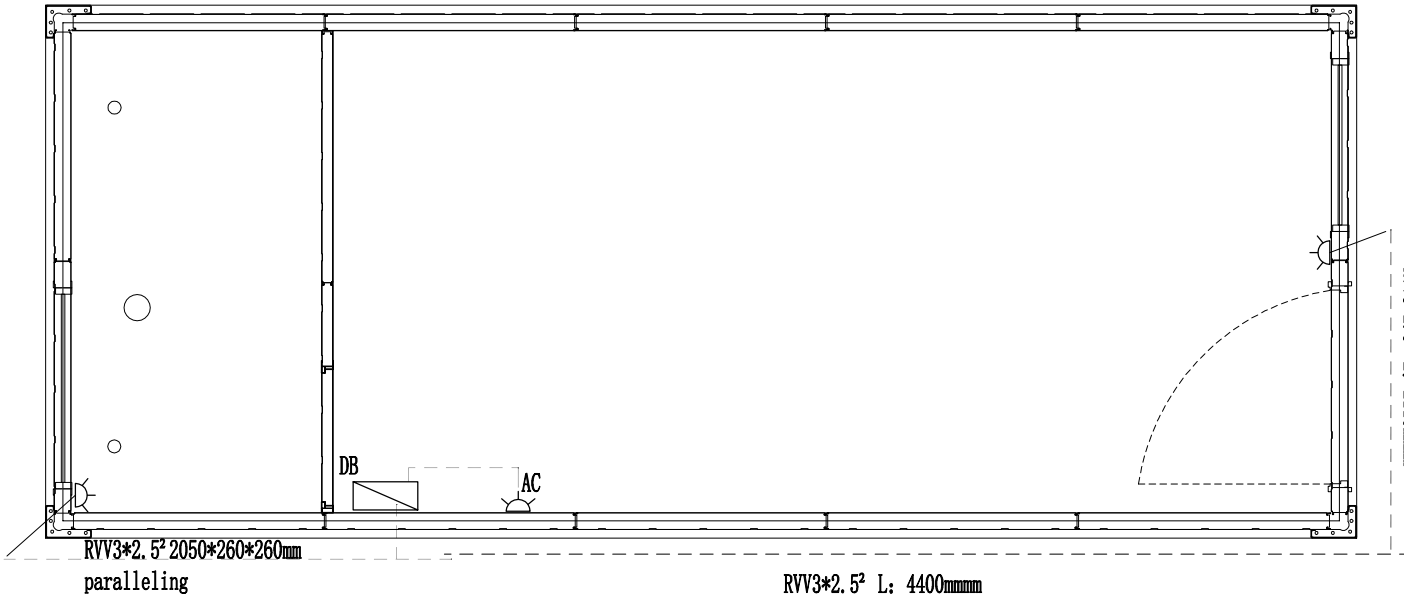

Socket layout

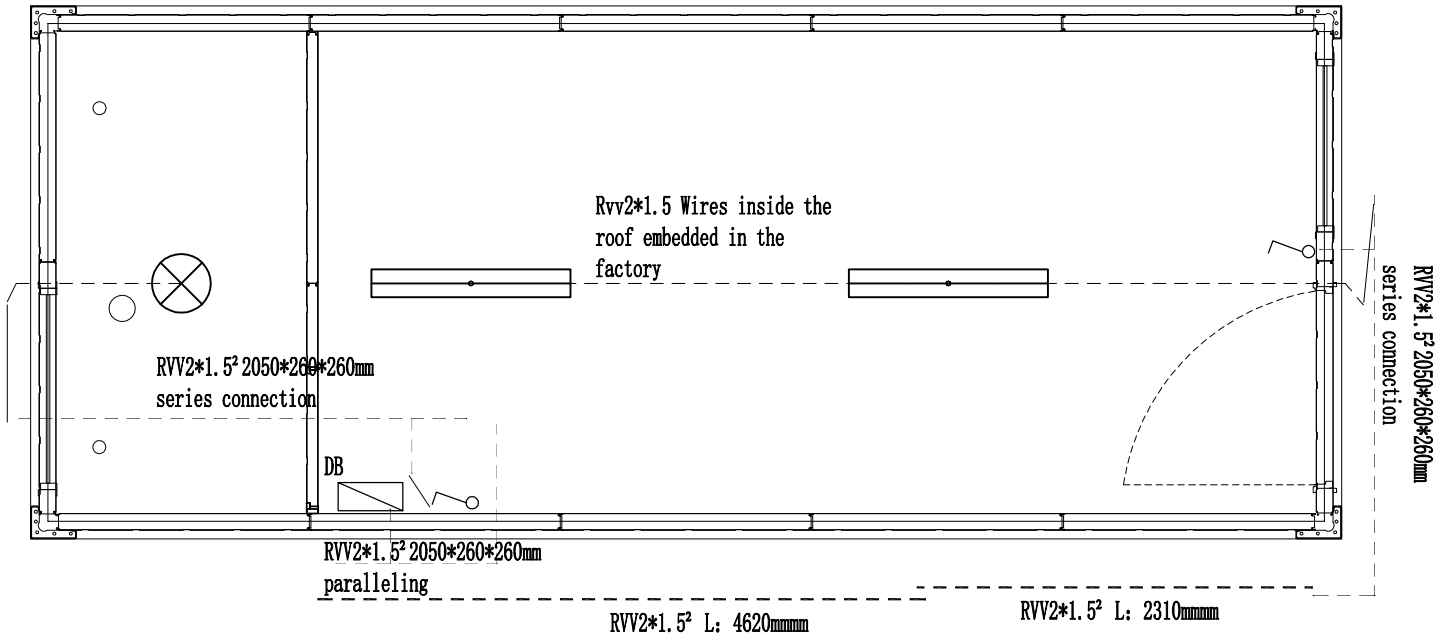

Switch layout

Copyright 2016.
This drawing remains the property of Hangzhou xixi Buildings Co.,Ltd.
It may only be used for the purpose for which it was commissioned &
in accordance with the terms of engagement for that commission.
Unauthorized use of this drawing is prohibited.

CUSTOMIZED BUILDINGS
Hangzhou Xixi Building Co., LTD
Mr. Cancan Kang
Cell Phone & Viber: 008613757163354
QQ & WeChat: 66048573 Email: cangcangbo@qq.com
Add.: 20th Floor, Xinyi Guangchang, Xiaoshan, Hangzhou,

Rev.	修改内容 Description	日期 Date	发布人 who send
------	---------------------	------------	-----------------

证书等级

证书编号

合作设计单位
Cooperative Designer

工 序 Process	签名 Signature	日 期 Date
审 定 Authorized By		
审 核 Verified By		
项目负责人 Process		
校对人 Checked By		
设 计 Designed By		
制 图 Drawn By		

执业签章
Engineer Signature

出图签章
Engineer Signature

项目名称
Project Name




图 名
Title
单箱电力布置

工程编号
Title
#678

比例
Scale

图号
Dwg.No.

未盖技术出图章 本图纸无效
This drawing is valid only after being stamped and released by the R&D

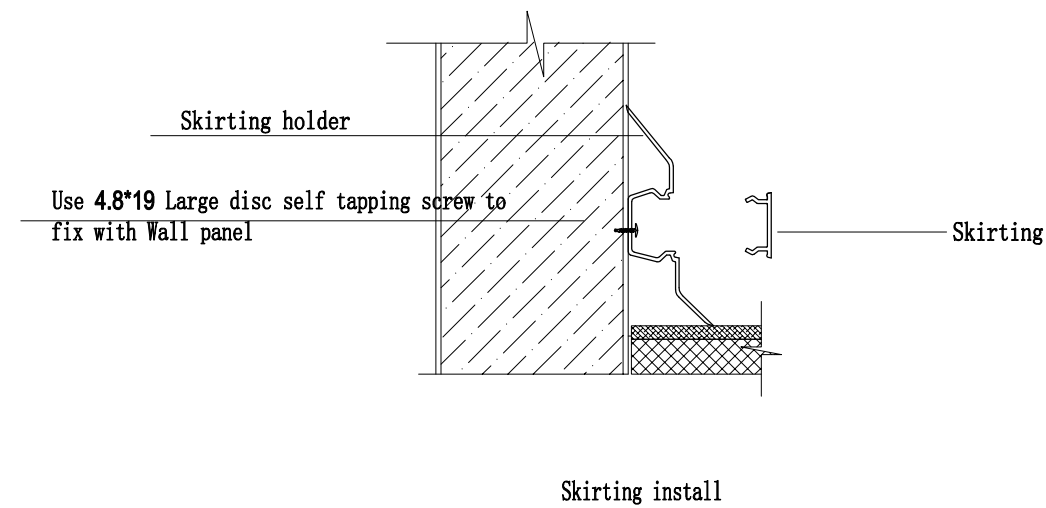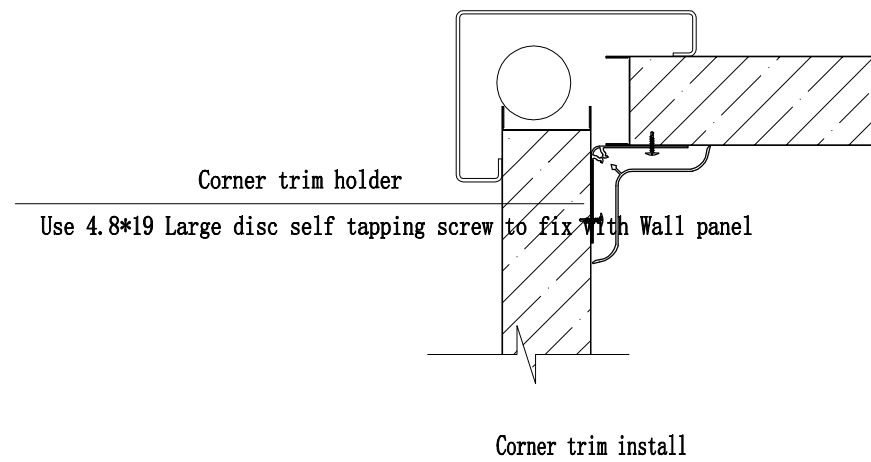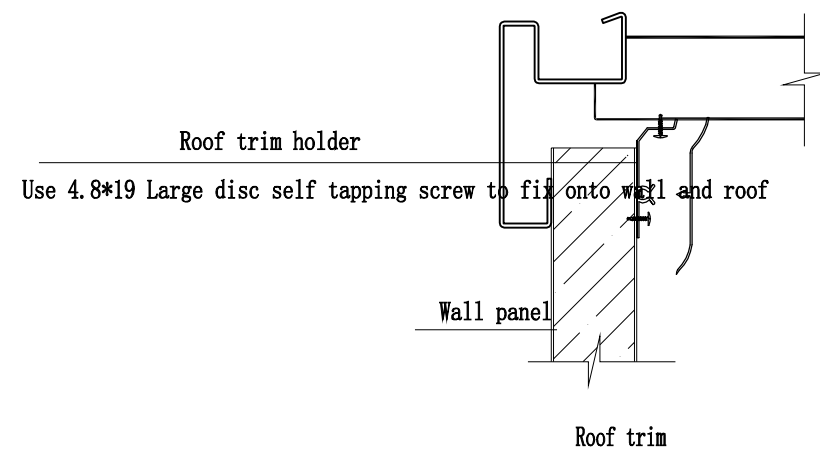

Copyright 2016.

This drawing remains the property of Hangzhou xixi Buildings Co., Ltd. It may only be used for the purpose for which it was commissioned and in accordance with the terms of engagement for that commission. Unauthorized use of this drawing is prohibited.




CUSTOMIZED BUILDINGS

Hangzhou Xixi Building Co., LTD


Mr. Cancan Kang
Cell Phone & WhatsApp & Viber: 008613757163354
QQ & WeChat: 66048573 Email: cancangbc@qq.com
Add.: 20th Floor, Xinyi Guangchang, Xiaoshan, Hangzhou,

版本 Rev.	修改内容 Description	日期 Date	发布人 who send
证书等级			
证书编号			
合作设计单位 Cooperative Designer			
工 序 Process	签名 Signature	日 期 Date	
审 定 Authorized By			
审 核 Verified By			
项目负责人 Process			
校对人 Checked By			
设 计 Designed By			
制 图 Drawn By			
执业签章 Engineer Signature			
出图签章 Engineer Signature			
项目名称 Project Name			
图 名 Title			
内饰条安装			
工程编号 Title	#878	专 业 Title	JZ
比例 Scale		图号 Dwg.No.	
未 盖 技 术 出 图 章 本 图 纸 无 效 This drawing is valid only after being stamped and released by the R&D			

电力	暖通	动力			
建筑	结构	给排水			
会签					

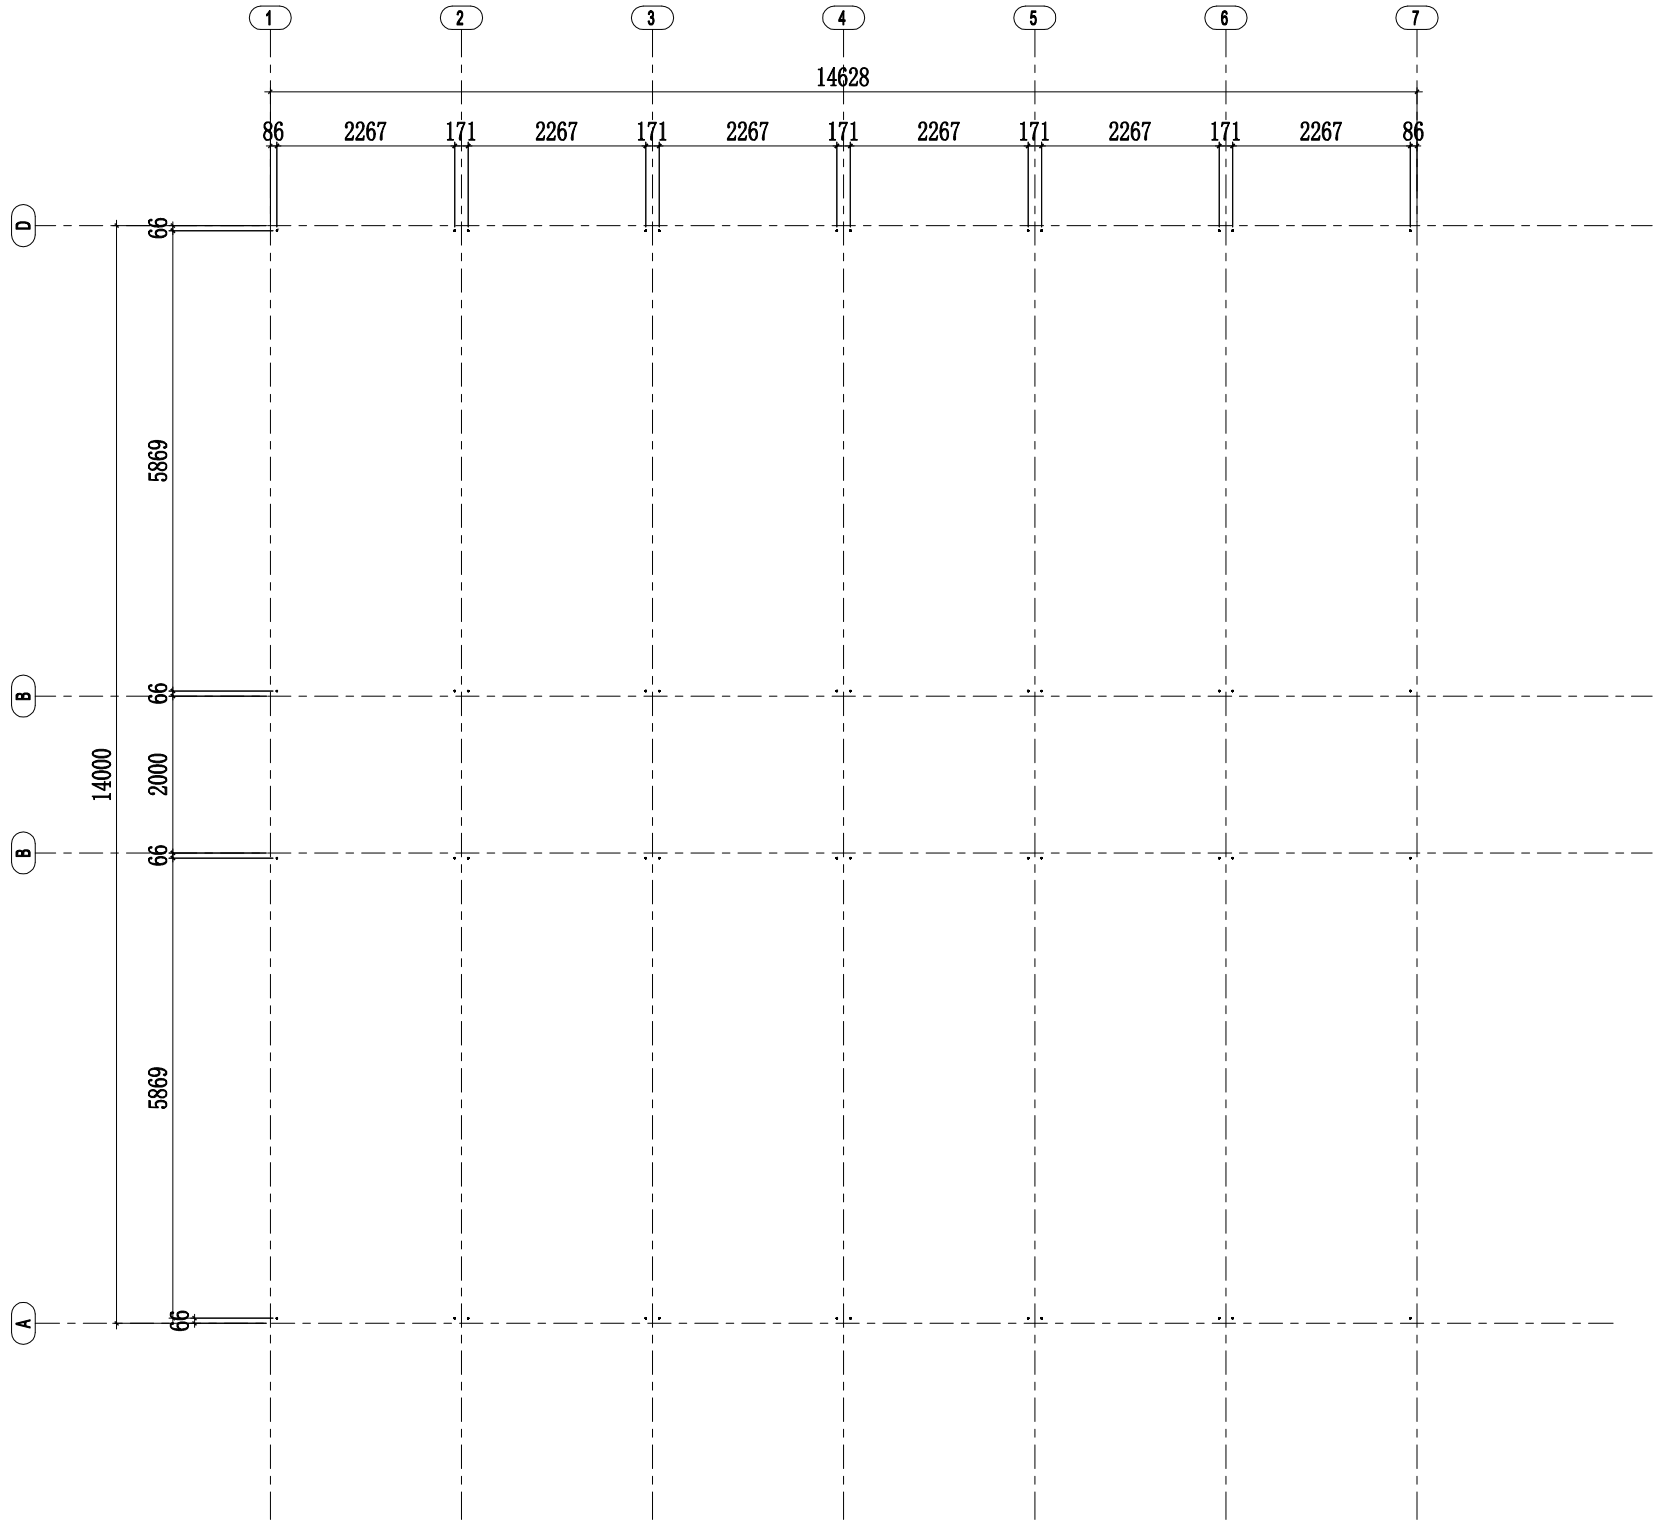

Anchor bolts layout

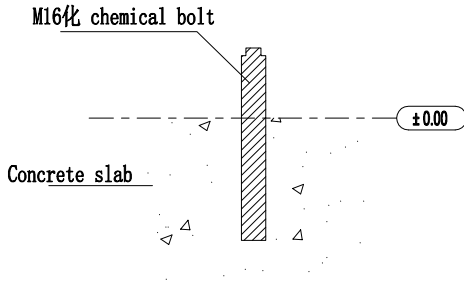

Copyright 2016.
This drawing remains the property of Hangzhou xixi Buildings Co.,Ltd.
It may only be used for the purpose for which it was commissioned &
in accordance with the terms of engagement for that commission.
Unauthorized use of this drawing is prohibited.



CUSTOMIZED BUILDINGS
Hangzhou Xixi Building Co., LTD
Mr. Cancan Kang
Cell Phone & WhatsApp & Viber: 008613757163354
QQ & WeChat: 66048573 Email: cancangbc@qq.com
Add.: 20th Floor, Xinyi Guangchang, Xiaoshan, Hangzhou,

版本 Rev.	修改内容 Description	日期 Date	发布人 who send

证书等级	
证书编号	
合作设计单位 Cooperative Designer	

工 序 Process	签名 Signature	日 期 Date
审 定 Authorized By		
审 核 Verified By		
项目负责人 Process		
校对人 Checked By		
设 计 Designed By		
制 图 Drawn By		

执业签章
Engineer Signature

出图签章
Engineer Signature

项目名称
Project Name

图 名
Title

箱底锚栓布置图


工程编号 Title	#878	专 业 Title	JZ
比例 Scale		图号 Dwg.No.	

未 盖 技 术 出 图 章 本 图 纸 无 效
This drawing is valid only after being stamped and released by the R&D


电力	暖通	动力			
建筑	结构	给排水			
会签					

Remark:

- hoist the assembled flatpack units to the foundation directly
- Make sure four corners of the flatpack are in the same level after put it onto the foundation
- Put the walkway panels between the flatpack containers

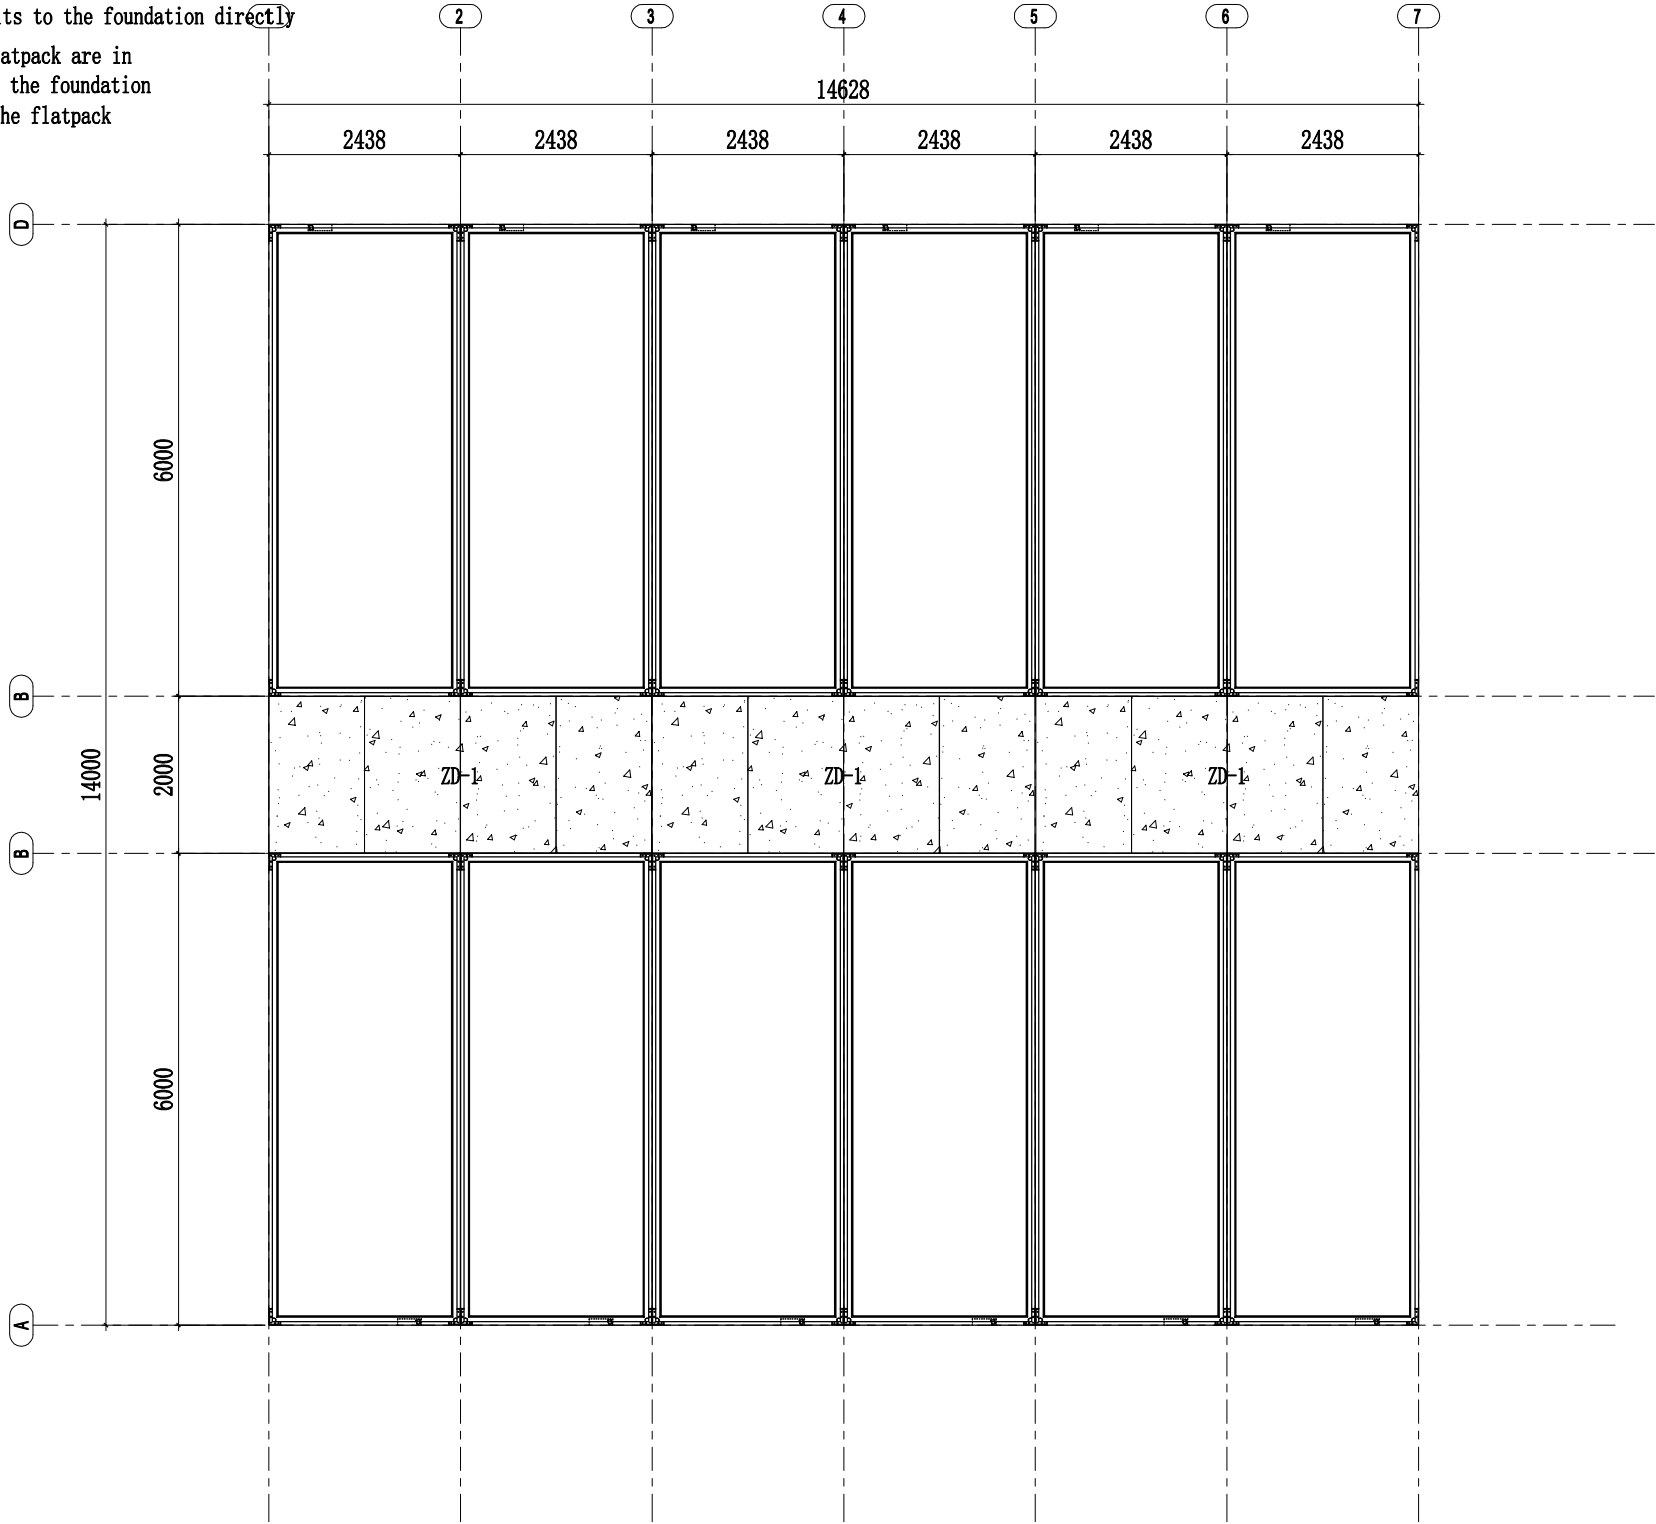

G.Floor flatpack install

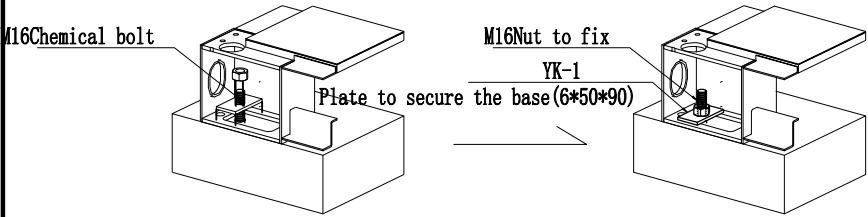

Flatpack base connect with the foundation 3d

Copyright 2016.
This drawing remains the property of Hangzhou xixi Buildings Co.,Ltd.
It may only be used for the purpose for which it was commissioned &
in accordance with the terms of engagement for that commission.
Unauthorized use of this drawing is prohibited.



CUSTOMIZED BUILDINGS

Hangzhou Xixi Building Co., LTD

Mr. Cancan Kang
Cell Phone & WhatsApp & Viber: 008613757163354
QQ & WeChat: 66048573 Email: cancangbc@qq.com
Add.: 20th Floor, Xinyi Guangchang, Xiaoshan, Hangzhou,

版本 Rev.	修改内容 Description	日期 Date	发布人 who send
------------	---------------------	------------	-----------------

证书等级

证书编号

合作设计单位
Cooperative Designer

工 序 Process	签名 Signature	日 期 Date
审 定 Authorized By		
审 核 Verified By		
项目负责人 Process		
校对人 Checked By		
设 计 Designed By		
制 图 Drawn By		

执业签章
Engineer Signature

出图签章
Engineer Signature



项目名称
Project Name

图 名
Title
箱底与基础连接

工程编号 Title	#878	专 业 Title	JZ
比 例 Scale		图 号 Dwg.No.	

未盖技术出图章 本图纸无效
This drawing is valid only after being stamped and released by the R&D

会 签	建 筑			电 力	
	结 构			暖 通	
	给 排 水			动 力	

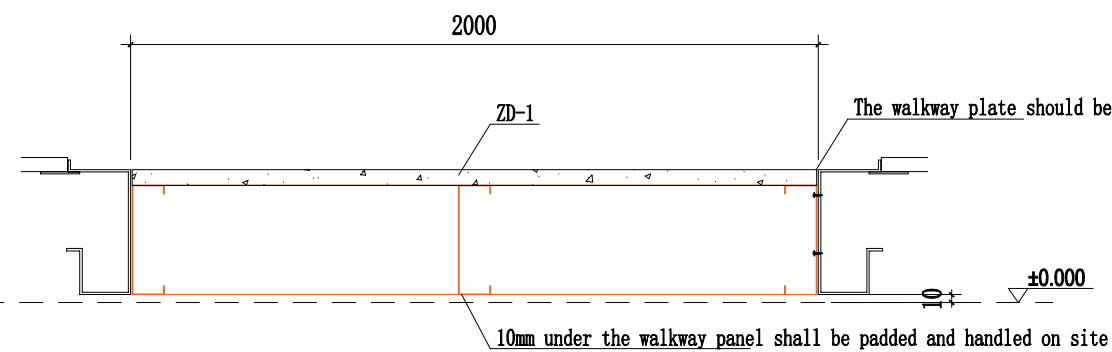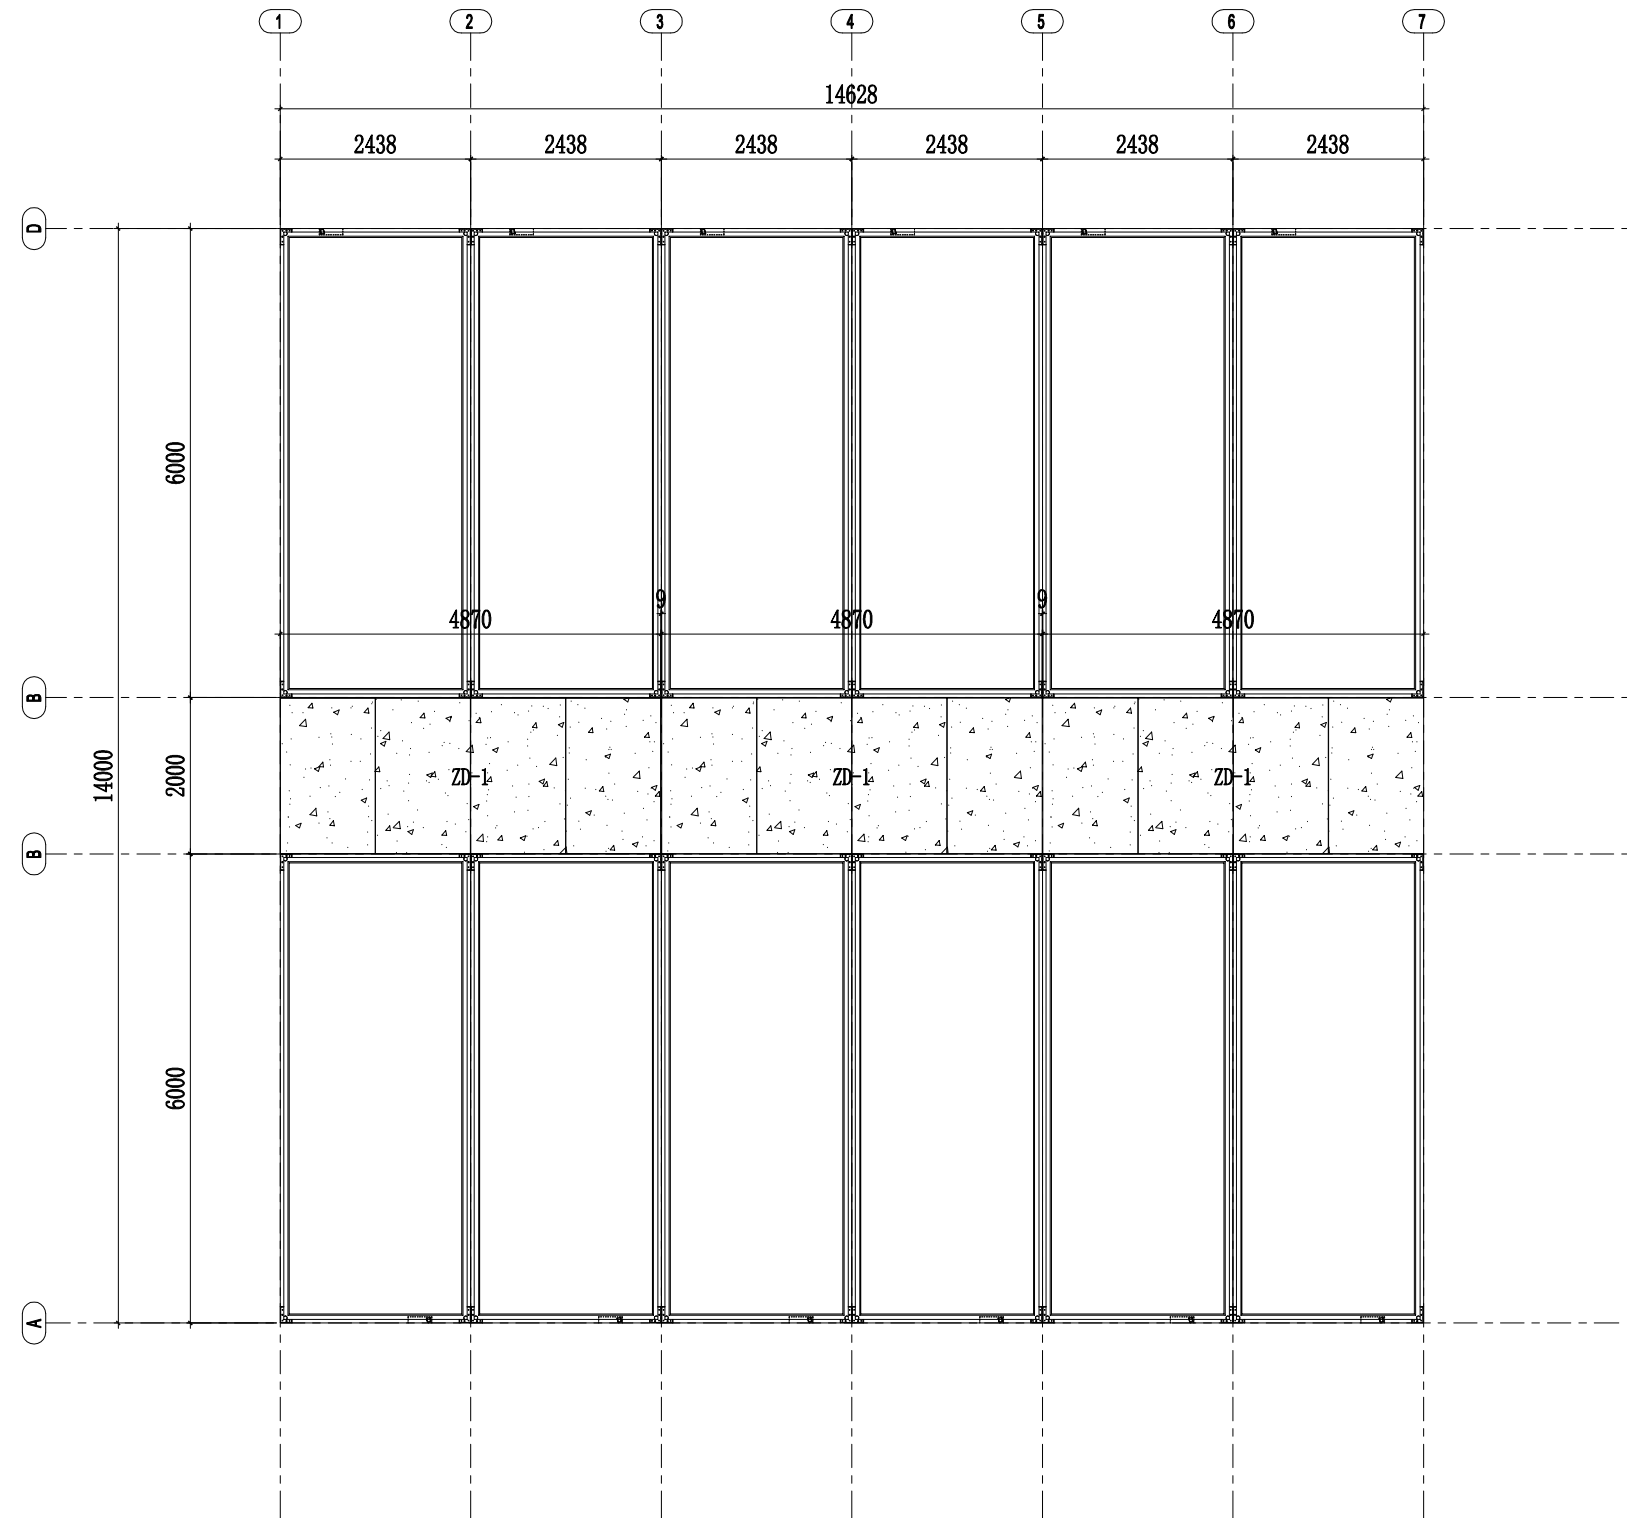

Walkway installation

Install the walkway of the G. floor

The walkway plate should be in the same level with the container bottom beam

Note: 1. Before put glue, clean the surface of cement fiberboard and apply glue evenly, with an area of about 2.8 square meters per kilogram of glue

2. After sticking pvc floor, roll evenly with roller.



3. Pvc floor can be installed finally

Copyright 2016.			
This drawing remains the property of Hangzhou xbd Buildings Co.,Ltd, it may only be used for the purpose for which it was commissioned & in accordance with the terms of engagement for that commission. Unauthorized use of this drawing is prohibited.			
 CUSTOMIZED BUILDINGS Hangzhou Xixi Building Co., LTD Mr. Cancan Kang Cell Phone & WhatsApp & Viber: 008613757163354 QQ & WeChat: 66048573 Email: cancangbc@qq.com Add.: 20th Floor, Xinyi Guangchang, Xiaoshan, Hangzhou,			
版本 Rev.	修改内容 Description	日期 Date	签发人 who send
证书等级			
证书编号			
合作设计单位 Cooperative Designer			
工 序 Process	签名 Signature	日 期 Date	
审 定 Authorized By			
审 核 Verified By			
项目负责人 Process			
校对人 Checked By			
设 计 Designed By			
制 图 Drawn By			
执业签章 Engineer Signature			
出图签章 Engineer Signature			
项目名称 Project Name			
图 名 Title			
一层走道安装			
工程编号 Title	#878	专 业 Title	JZ
比例 Scale		图号 Dep.No.	
未 盖 技 术 出 图 章 本 图 纸 无 效 This drawing is valid only after being stamped and released by the R&D			

电力	暖通	动力			
建筑	结构	给排水			
会	签				

Install walkway in F.Floor:

1. Put the walkway between the containers according to the position showed and keep them the same level with the container beam

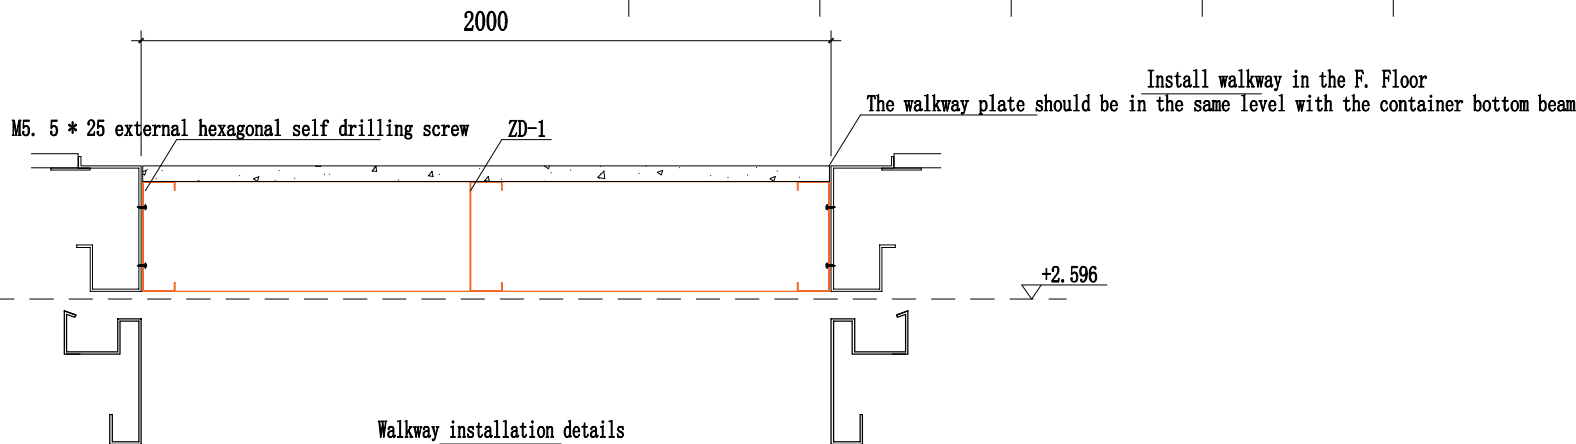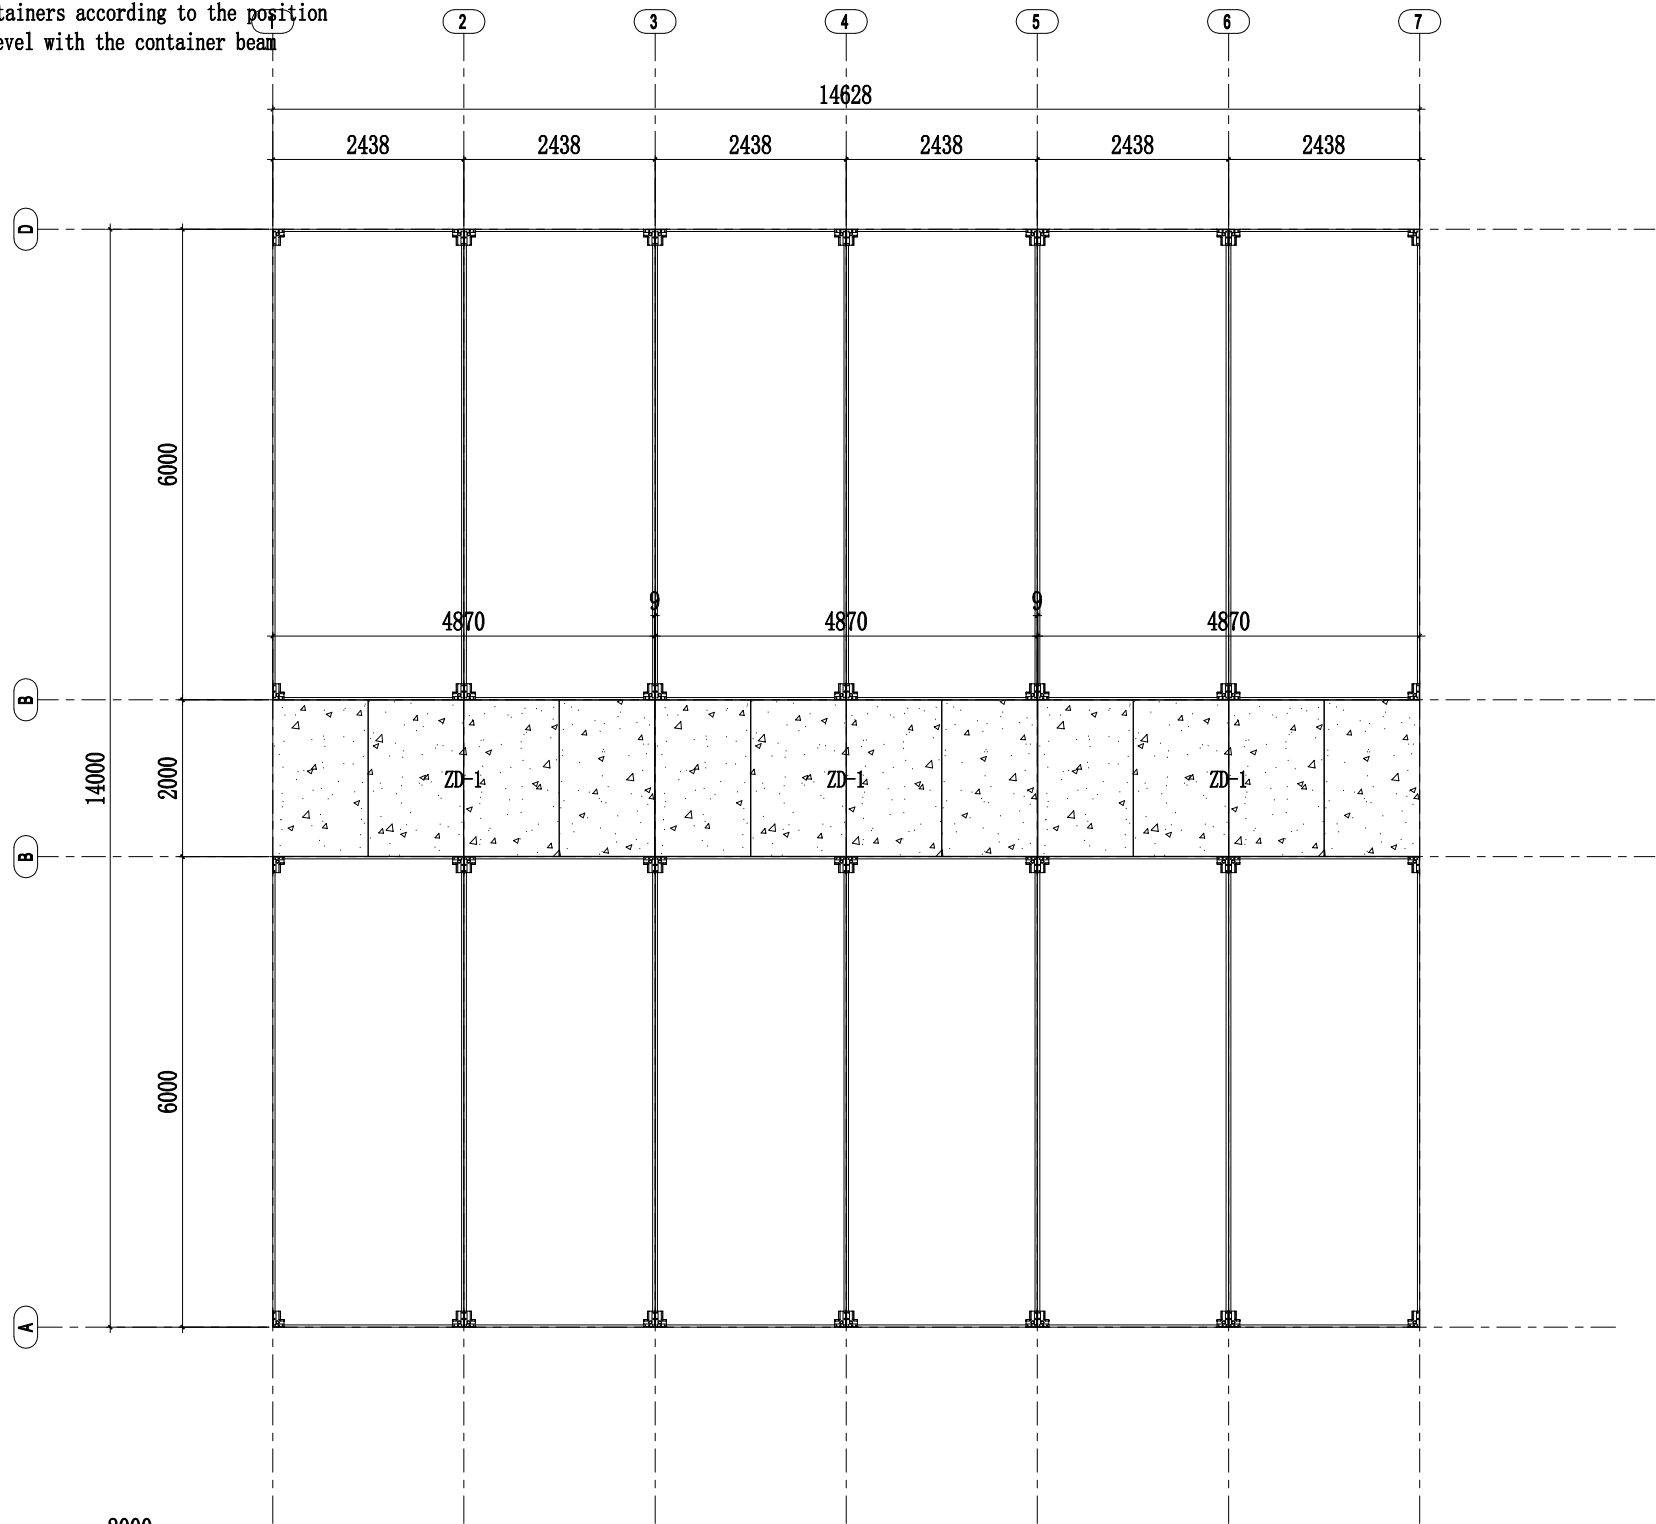

Walkway installation details

Note: 1. Before put glue, clean the surface of cement fiberboard and apply glue evenly, with an area of about 2.8 square meters per kilogram of glue

2. After sticking pvc floor, roll evenly with roller.

3. Pvc floor can be installed finally

Copyright 2016.

This drawing remains the property of Hangzhou xixi Buildings Co., Ltd. It may only be used for the purpose for which it was commissioned & in accordance with the terms of engagement for that commission. Unauthorized use of this drawing is prohibited.



CUSTOMIZED BUILDINGS

Hangzhou Xixi Building Co., LTD

Mr. Cancan Kang
Cell Phone & WhatsApp & Viber: 008613757163354
QQ & WeChat: 66048573 Email: cancangbc@qq.com
Add.: 20th Floor, Xinyi Guangchang, Xiaoshan, Hangzhou,

版本	修改内容	日期	负责人
Rev.	Description	Date	who send

证书等级

证书编号

合作设计单位
Cooperative Designer

工 序	签名	日 期
Process	Signature	Date
审 定		
Authorized By		
审 核		
Verified By		
项目负责人		
Process		
校对人		
Checked By		
设 计		
Designed By		
制 图		
Drawn By		

执业签章
Engineer Signature

出图签章
Engineer Signature

项目名称
Project Name



图 名
Title

二层走道安装

工程编号	#878	专 业	JZ
Title		Title	
比例		图号	
Scale		Draw.No.	

未 盖 技 术 出 图 章 本 图 纸 无 效
This drawing is valid only after being stamped and released by the R&D

会	建筑			电力	
签	结构			暖通	
	给排水			动力	

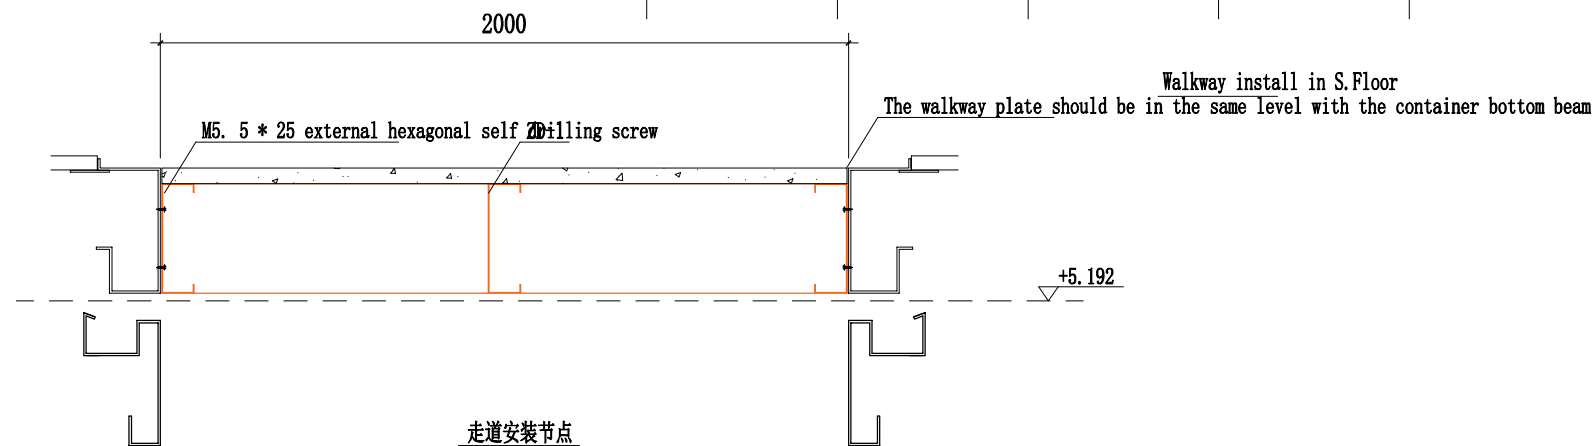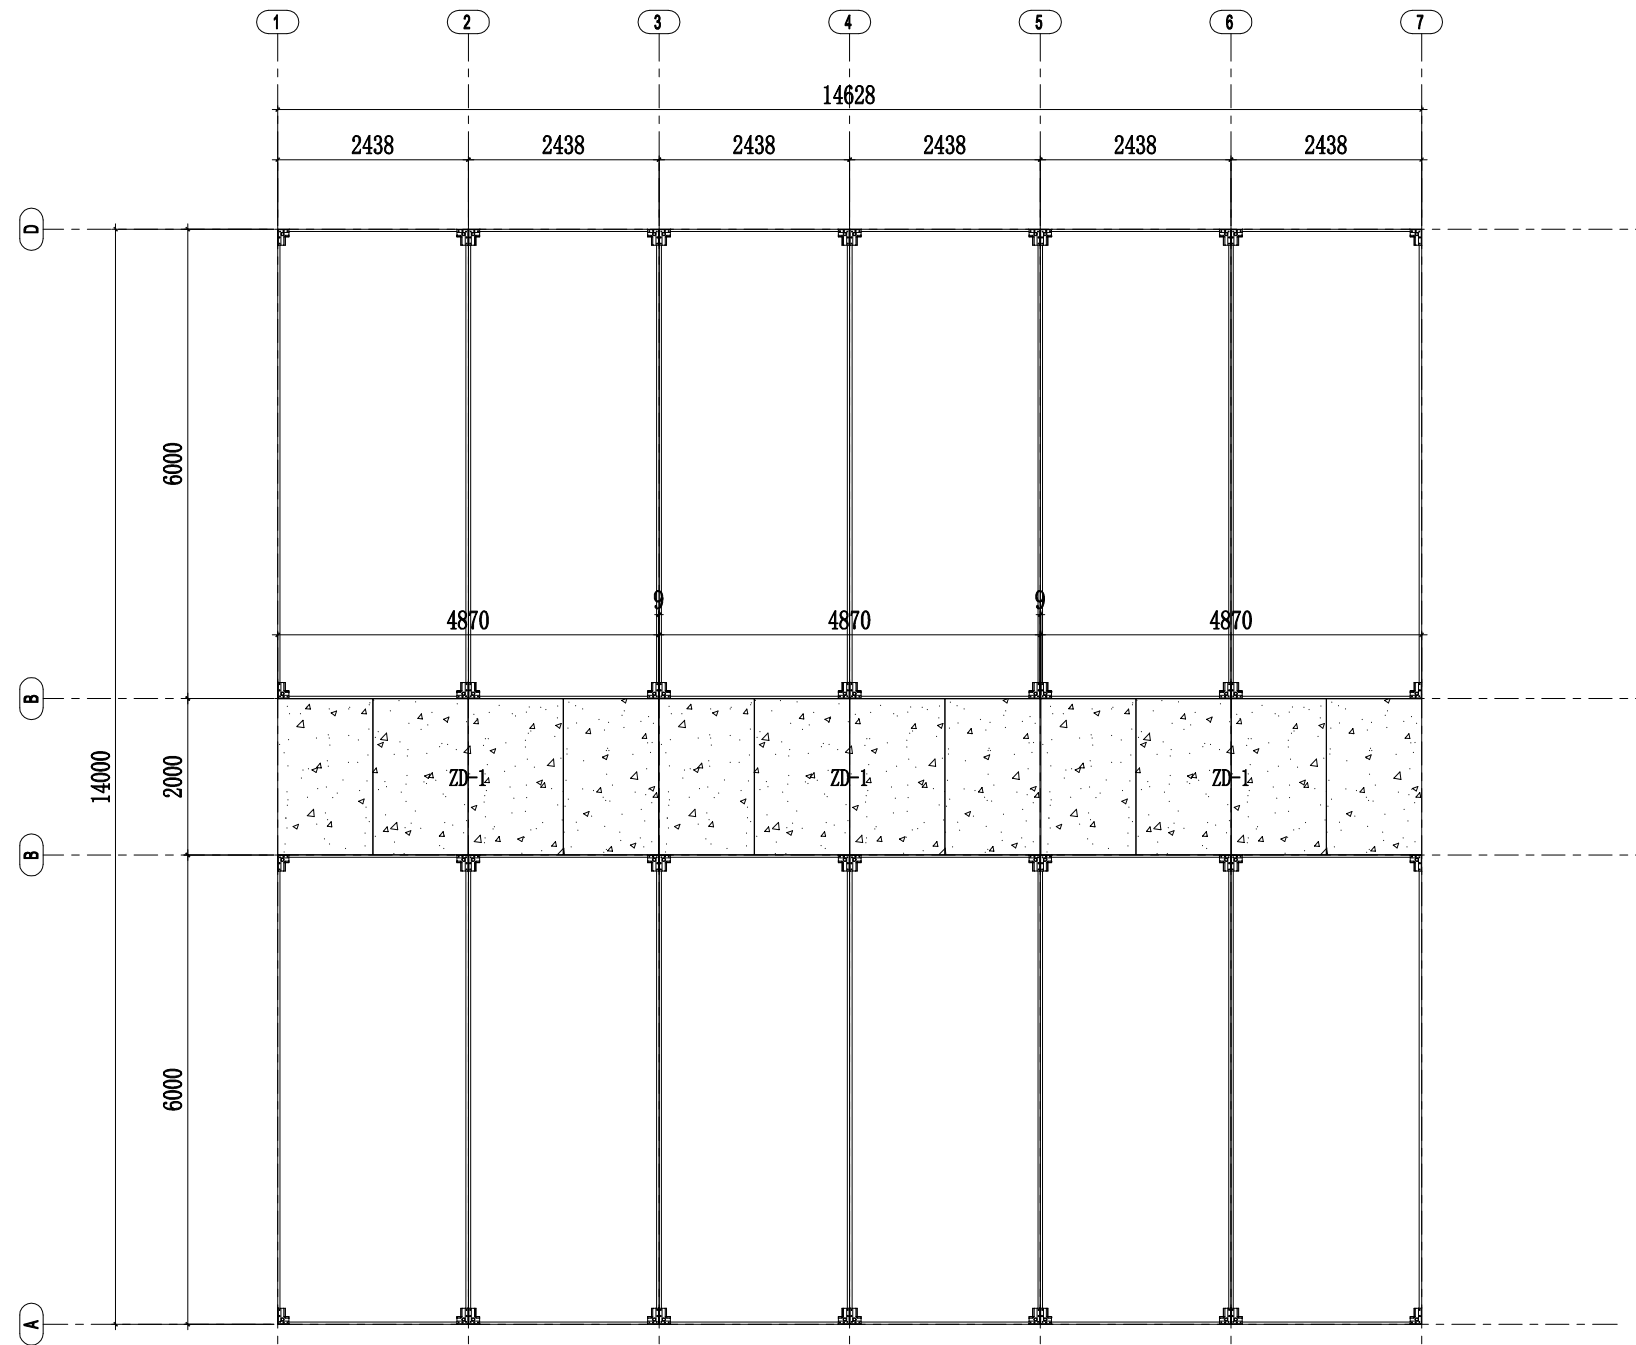

Note: 1. Before put glue, clean the surface of cement fiberboard and apply glue evenly, with an area of about 2.8 square meters per kilogram of glue

2. After sticking pvc floor, roll evenly with roller.

3. Pvc floor can be installed finally

Copyright 2016.

This drawing remains the property of Hangzhou Xixi Buildings Co., Ltd. It may only be used for the purpose for which it was commissioned and in accordance with the terms of engagement for that commission. Unauthorized use of this drawing is prohibited.



Hangzhou Xixi Building Co., LTD

Mr. Cancan Kang
Cell Phone & WhatsApp & Viber: 008613757163354
QQ & WeChat: 66048573 Email: cancanbcb@qq.com
Add.: 20th Floor, Xinyi Guangchang, Xiaoshan, Hangzhou,

版本 Rev.	修改内容 Description	日期 Date	发布人 who send
------------	---------------------	------------	-----------------

证书等级	
证书编号	

合作设计单位 Cooperative Designer	
--------------------------------	--

工 序 Process	签名 Signature	日 期 Date
审 定 Authorized By		
审 核 Verified By		
项目负责人 Process		
校对人 Checked By		
设 计 Designed By		
制 图 Drawn By		

执业签章
Engineer Signature

出图签章
Engineer Signature

项目名称	Project Name
------	--------------

图名 Title	三层走道安装
-------------	--------



工程编号 Title	#878	专业 Title	JZ
比例 Scale		图号 Dwg.No.	

未盖技术出图章 本图纸无效
This drawing is valid only after being stamped and released by the R&D

电力	暖通	动力			
建筑	结构	给排水			
会	签				

Ceiling for the walkway

- refer to the ceiling layout
- Use M5. 5 * 25 external hexagonal self drilling screw to fix the ceiling

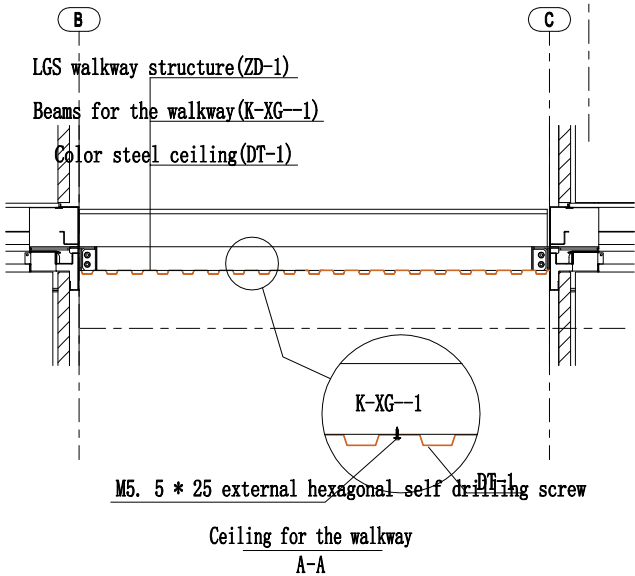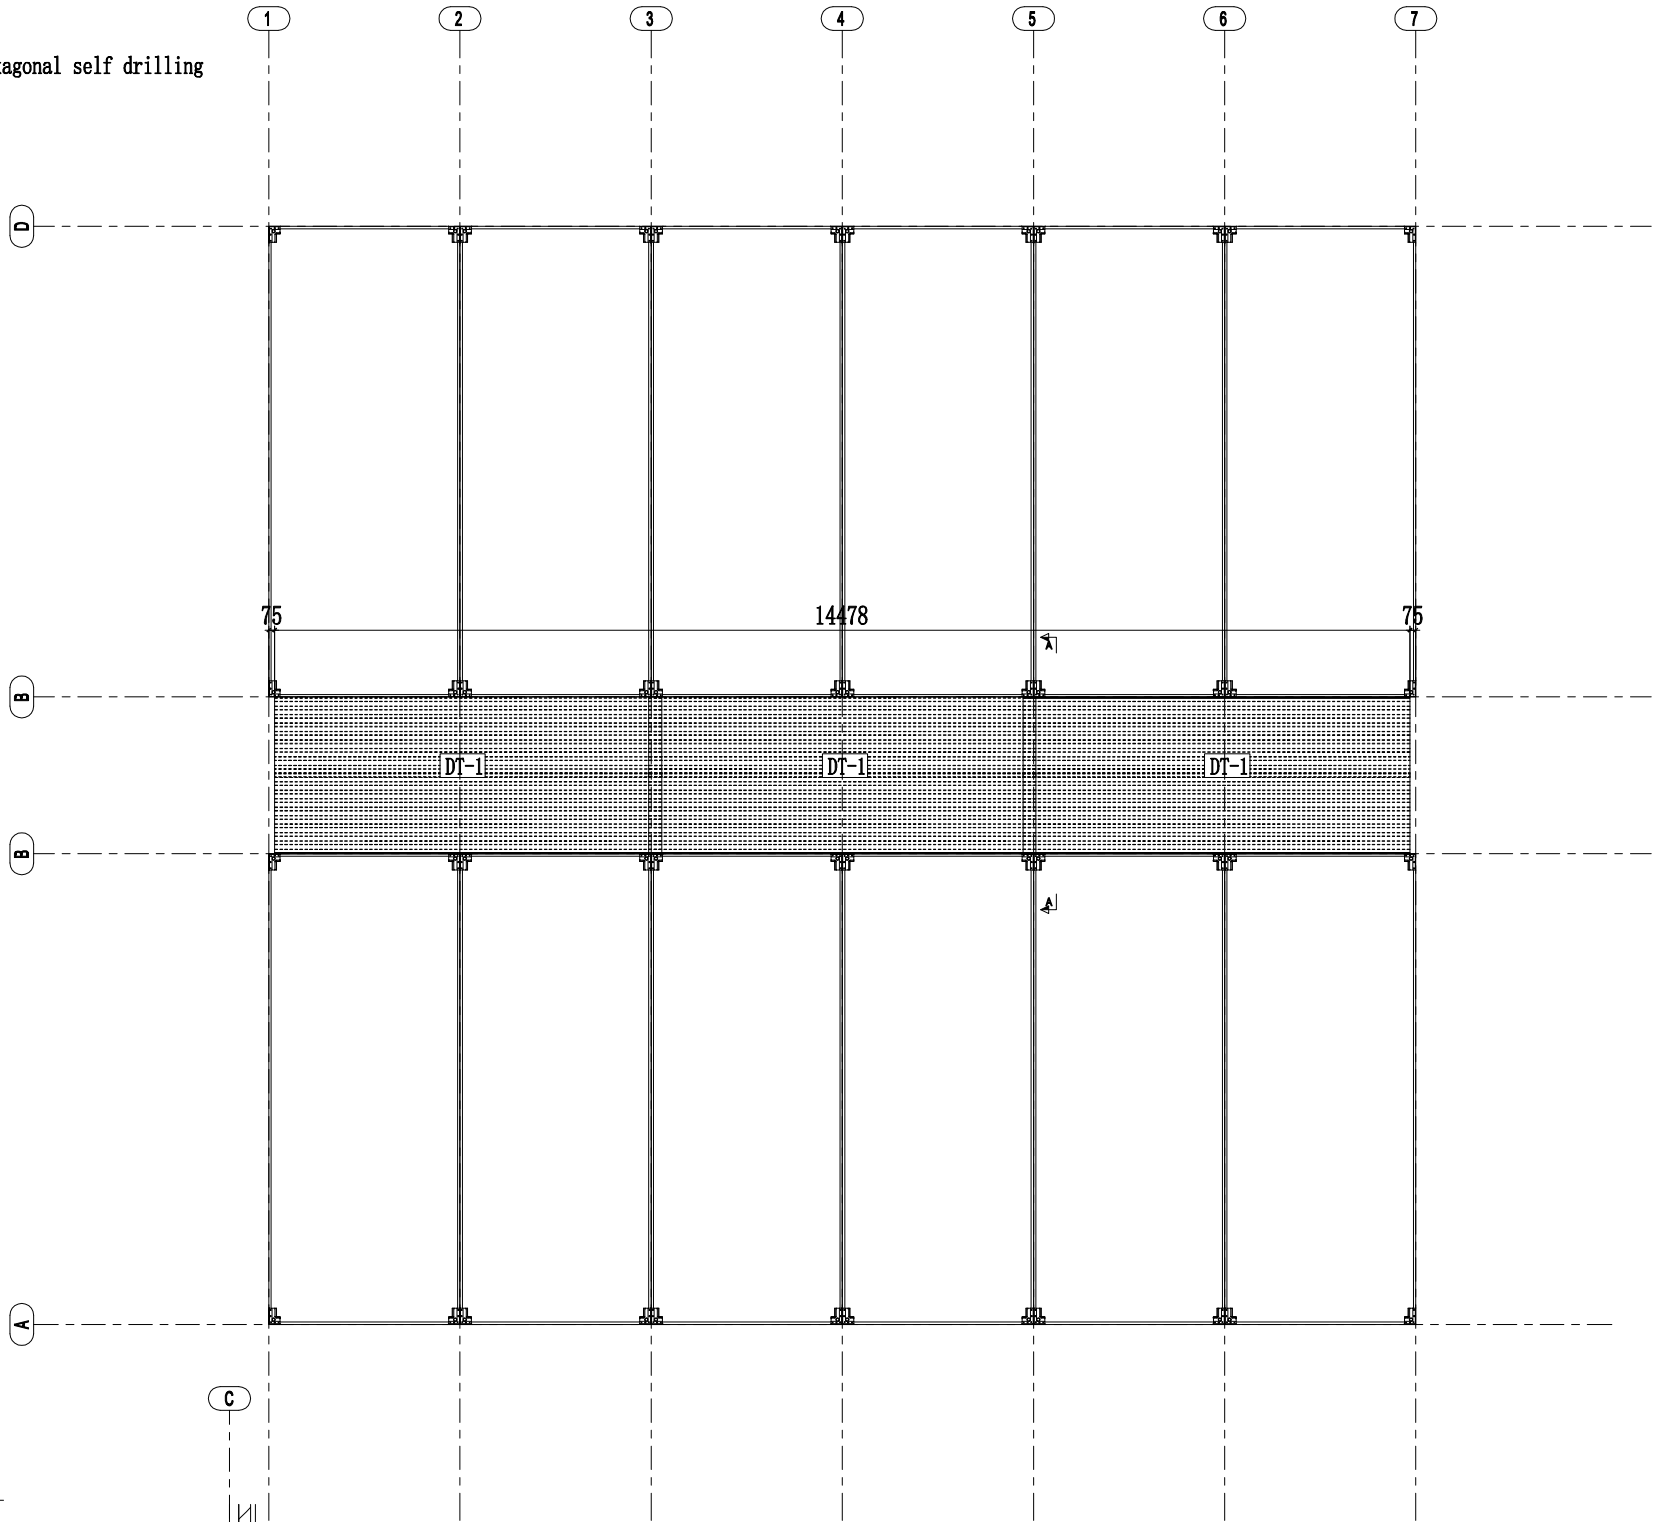

Copyright 2016.
This drawing remains the property of Hangzhou xbi Buildings Co.,Ltd.
it may only be used for the purpose for which it was commissioned &
in accordance with the terms of engagement for that commission.
Unauthorized use of this drawing is prohibited.



CUSTOMIZED BUILDINGS
Hangzhou Xixi Building Co., LTD
Mr. Cancan Kang
Cell Phone & WhatsApp & Viber: 008613757163354
QQ & WeChat: 66048573 Email: cancangbc@qq.com
Add.: 20th Floor, Xinyi Guangchang, Xiaoshan, Hangzhou,

版本 Rev.	修改内容 Description	日期 Date	负责人 who send
------------	---------------------	------------	-----------------

证书等级

证书编号

合作设计单位
Cooperative Designer

工 序 Process	签名 Signature	日 期 Date
审 定 Authorized By		
审 核 Verified By		
项目负责人 Process		
校对人 Checked By		
设 计 Designed By		
制 图 Drawn By		

执业签章
Engineer Signature

出图签章
Engineer Signature

项目名称
Project Name



图 名
Title
走道吊顶安装

工程编号
Title
#878


比例
Scale
图号
Dwg.No.
JZ

未 盖 技 术 出 图 章 本 图 纸 无 效
This drawing is valid only after being stamped and released by the R&D

电力	暖通	动力			
建筑	结构	给排水			
会签					

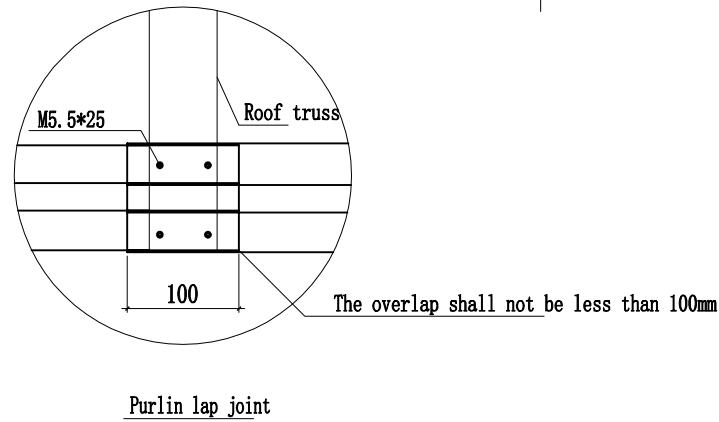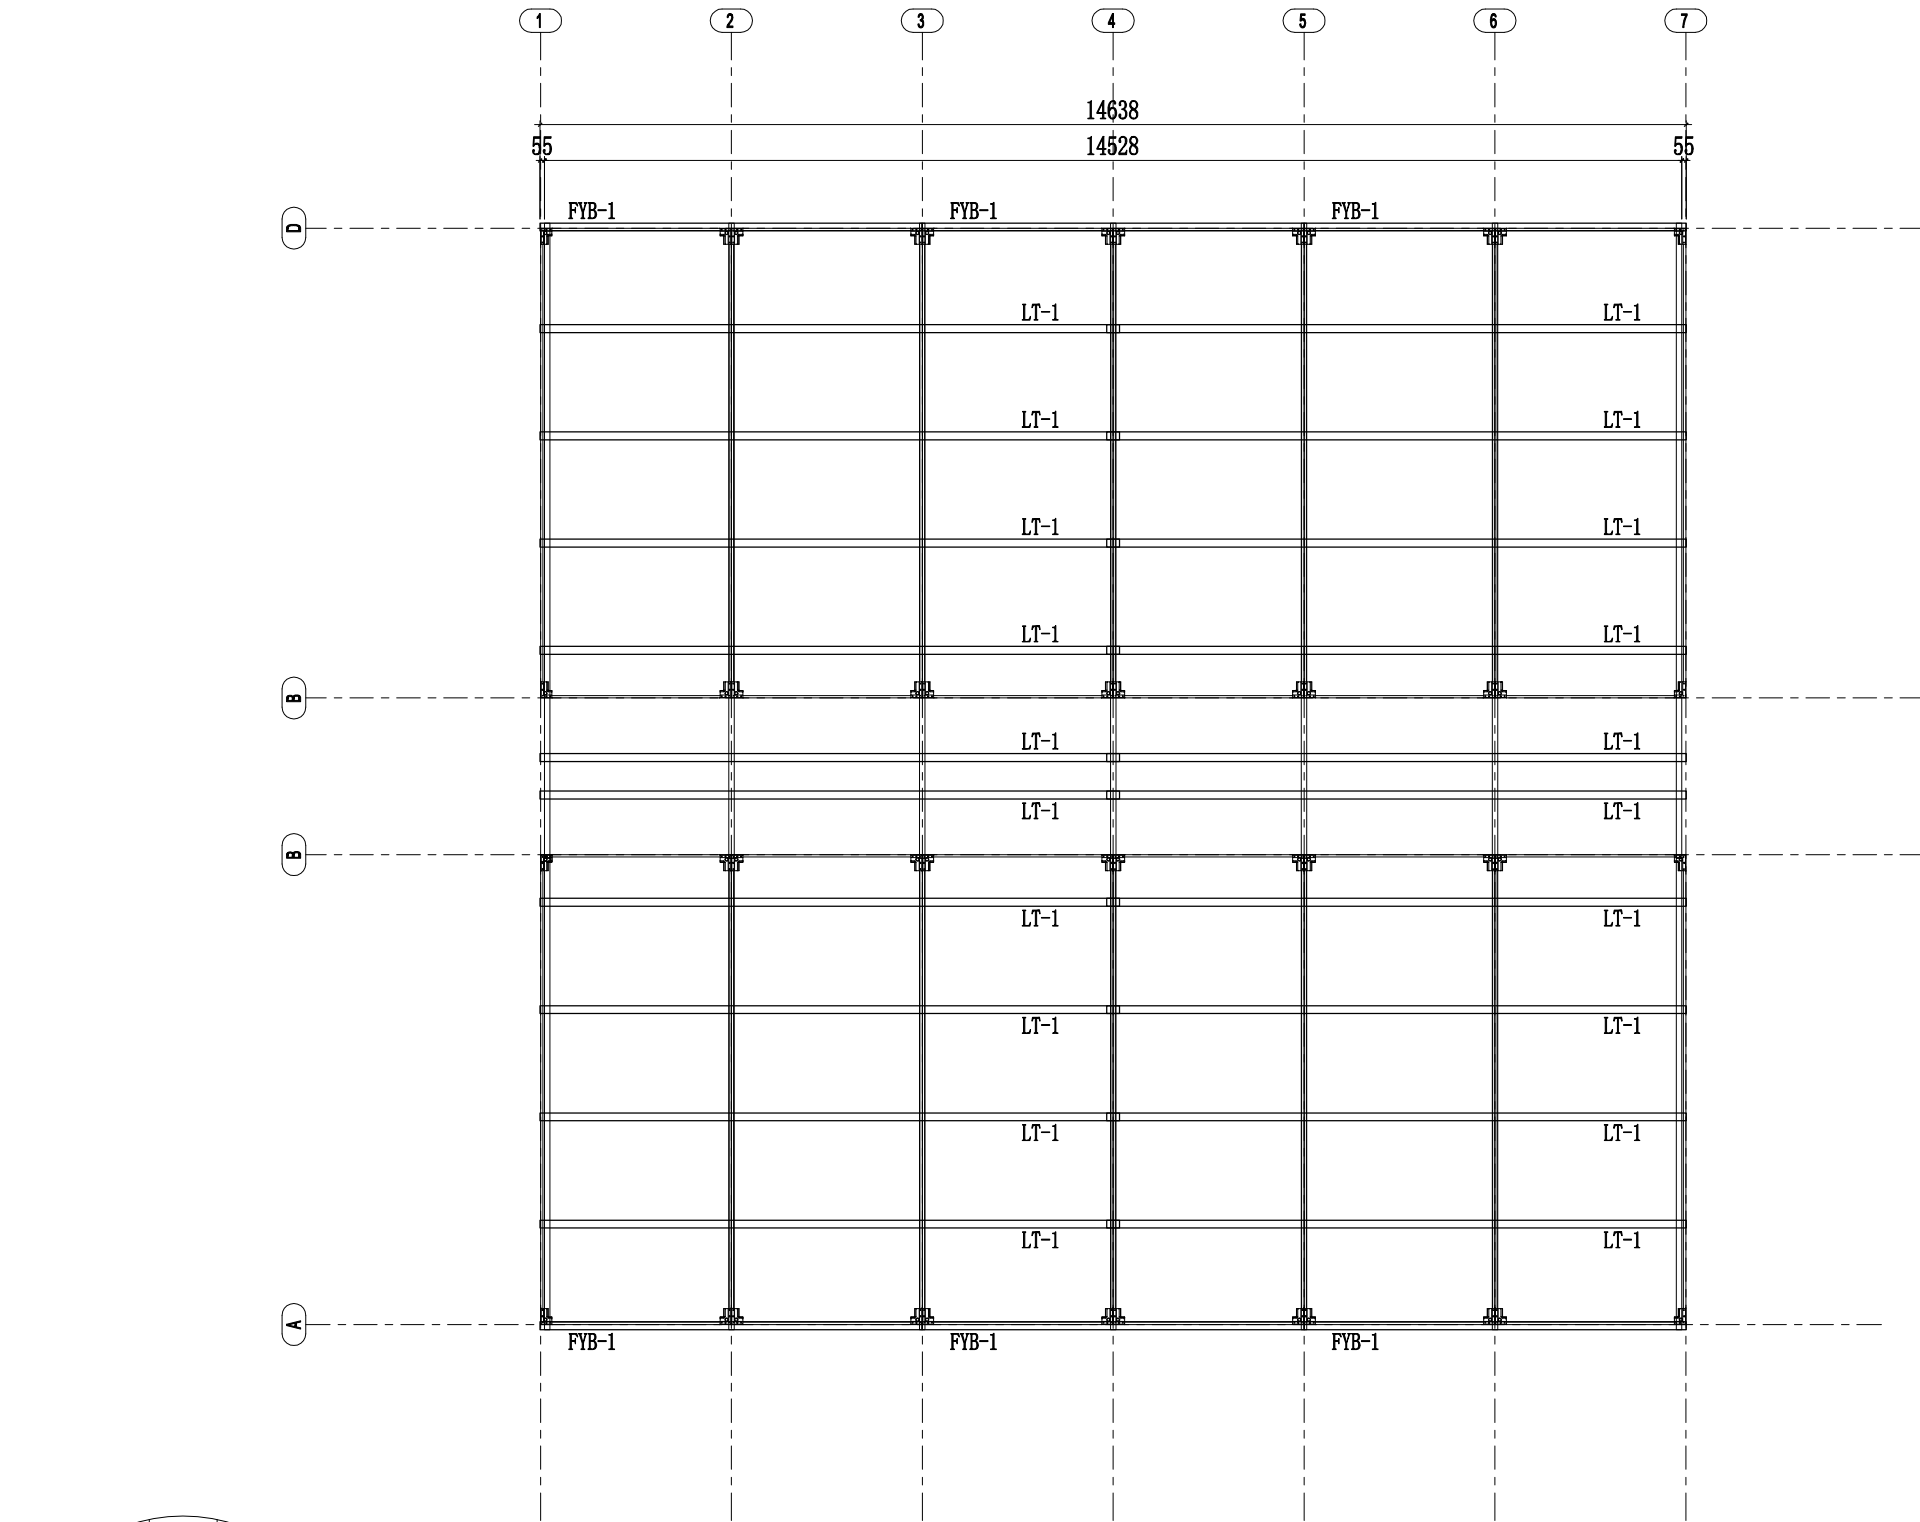

Roof purlin installation

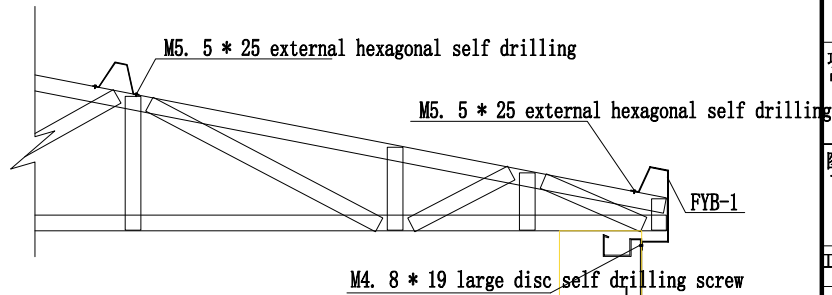

Purlin installation node

Copyright 2016.

This drawing remains the property of Hangzhou xixi Buildings Co.,Ltd. It may only be used for the purpose for which it was commissioned & in accordance with the terms of engagement for that commission. Unauthorized use of this drawing is prohibited.



CUSTOMIZED BUILDINGS

Hangzhou Xixi Building Co., LTD

Mr. Cancan Kang
Cell Phone & WhatsApp & Viber: 008613757163354
QQ & WeChat: 66048573 Email: cancangbc@qq.com
Add.: 20th Floor, Xinyi Guangchang, Xiaoshan, Hangzhou,

Rev.	Description	Date	who send

证书等级

证书编号

合作设计单位
Cooperative Designer

工 序 Process	签名 Signature	日 期 Date
审 定 Authorized By		
审 核 Verified By		
项目负责人 Process		
校对人 Checked By		
设 计 Designed By		
制 图 Drawn By		

执业签章
Engineer Signature

出图签章
Engineer Signature

项目名称
Project Name


图 名
Title

屋面檩条安装


工程编号 Title	#878	专 业 Title	JZ
比 例 Scale		图号 Dwg.No.	

未 盖 技 术 出 图 章 本 图 纸 无 效
This drawing is valid only after being stamped and released by the R&D

会 签	建 筑			电 力	
	结 构			暖 通	
	给 排 水			动 力	

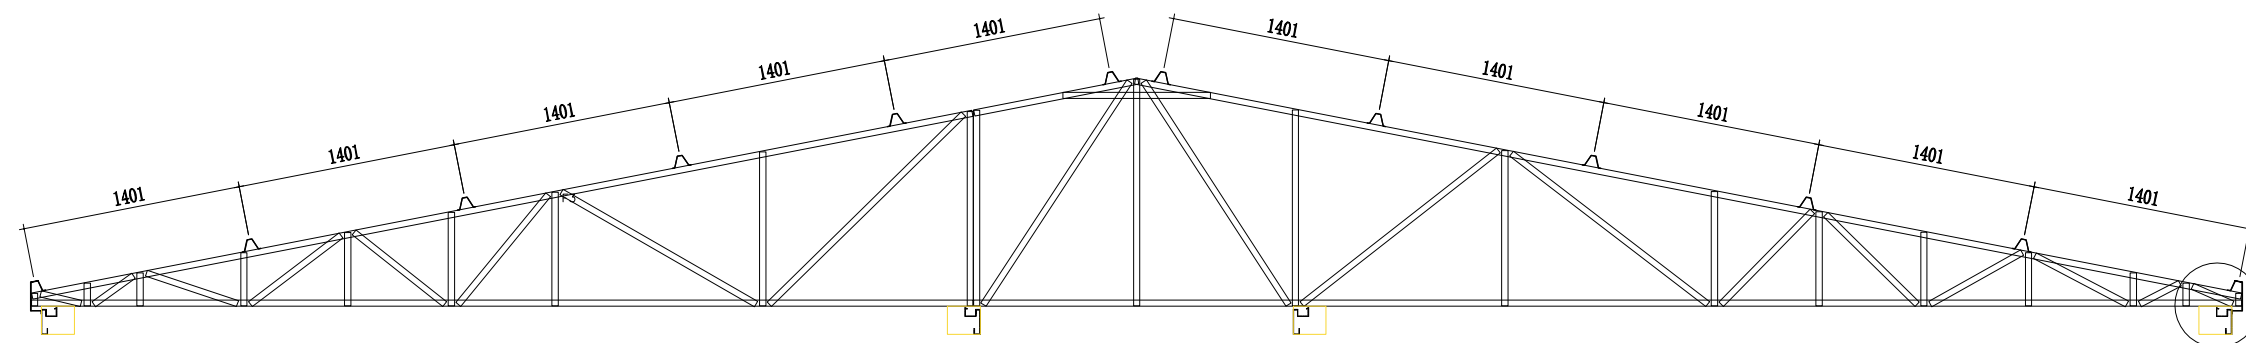

Roof purlin layout

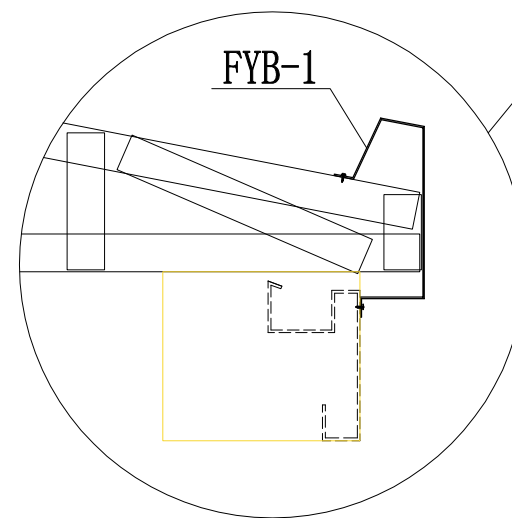

Copyright 2016.

This drawing remains the property of Hangzhou xbd Buildings Co.,Ltd.
It may only be used for the purpose for which it was commissioned &
in accordance with the terms of engagement for that commission.
Unauthorized use of this drawing is prohibited.



Hangzhou Xixi Building Co., LTD

Mr. Cancan Kang
Cell Phone & WhatsApp & Viber: 008613757163354
QQ & WeChat: 66048573 Email: cancancbc@qq.com
Add.: 20th Floor, Xinyi Guangchang, Xiaoshan, Hangzhou,

版本 Rev.	修改内容 Description	日期 Date	发布人 who send
------------	---------------------	------------	-----------------

证书等级	
------	--

证书编号	
------	--

合作设计单位

工 序 Process	签名 Signature	日 期 Date
审 定 Authorized By		
审 核 Verified By		
项目负责人 Process		
校对人 Checked By		
设 计 Designed By		
制 图 Drawn By		

执业签章
Engineer Signature

出图签章
Engineer Signature

项目名称
Project Name

图名	Time
----	------

標条布置

工程编号 Title	#878	专业 The	JZ
---------------	------	-----------	----


比例 Scale	图号 Dwg.No.
-------------	---------------

未盖技术出图章 本图纸无效
This drawing is valid only after being stamped and released by the R&D


电	力	暖	通	动	力
建	筑	结	构	给	排
会	签				

Layout of gable wall panel

1. Install the gable wall panel before the roof panel
2. Install the flashing before the gable wall panel
3. Use M4. 8 * 19 large disc self drilling screw to fix the flashing
4. Use M5. 5 * 25 external hexagonal self drilling screw to fix the gable wall panel

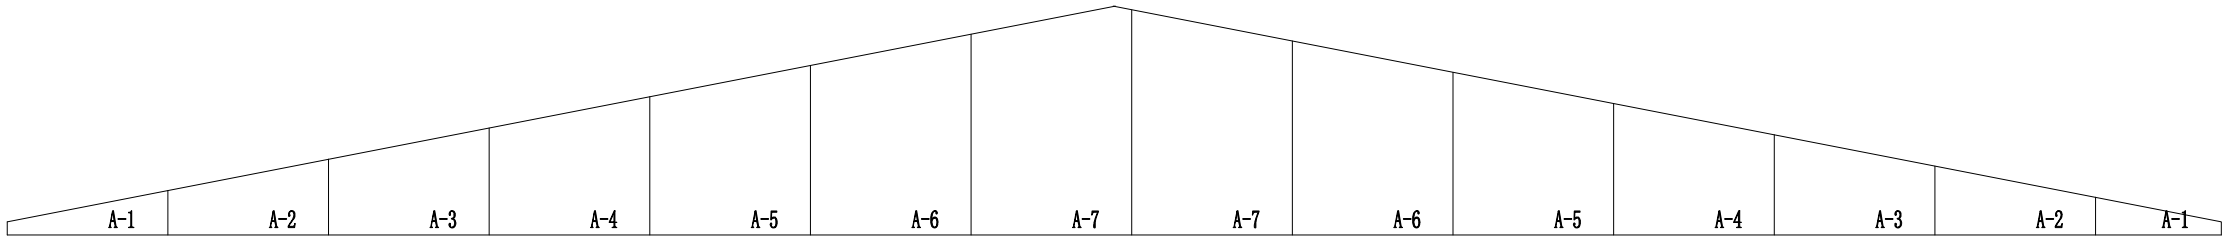

Layout of gable wall panel

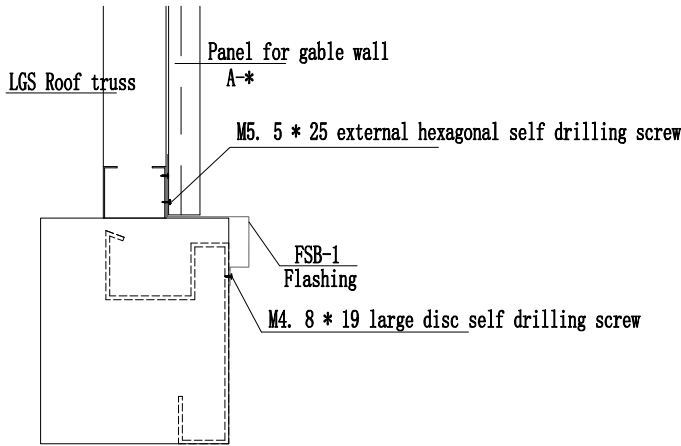

Gable wall flashing installation node

Copyright 2016.

This drawing remains the property of Hangzhou xxi Buildings Co.,Ltd. It may only be used for the purpose for which it was commissioned & in accordance with the terms of engagement for that commission. Unauthorized use of this drawing is prohibited.



Hangzhou Xixi Building Co., LTD

Mr. Cancan Kang
Cell Phone & WhatsApp & Viber: 008613757163354
QQ & WeChat: 66048573 Email: cancangbc@qq.com
Add.: 20th Floor, Xinyi Guangchang, Xiaoshan, Hangzhou,

版本 Rev.	修改内容 Description	日期 Date	负责人 who send
------------	---------------------	------------	-----------------

证书等级

证书编号

合作设计单位
Cooperative Designer

工 序 Process	签名 Signature	日 期 Date
审 定 Authorized By		
审 核 Verified By		
项目负责人 Process		
校对人 Checked By		
设 计 Designed By		
制 图 Drawn By		

执业签章
Engineer Signature

出图签章
Engineer Signature

项目名称
Project Name


图 名
Title

山墙封板布置

工程编号 Title	#878	专 业 Title	JZ
比例 Scale		图号 Des.No.	


未 盖 技 术 出 图 章 本 图 纸 无 效
This drawing is valid only after being stamped and released by the R&D

会 签	建 筑			电 力		
	结 构			暖 通		
	给 排 水			动 力		

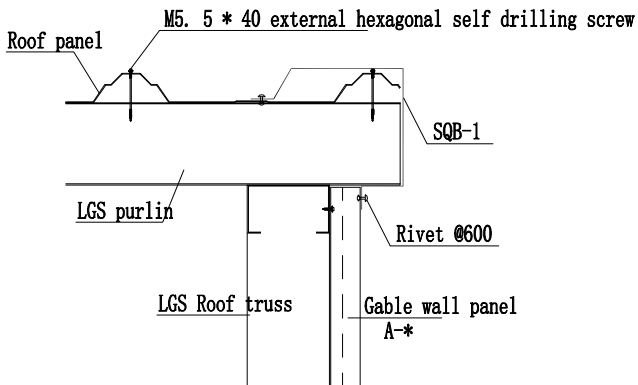

Gable wall flashing installation

Roof panel layout

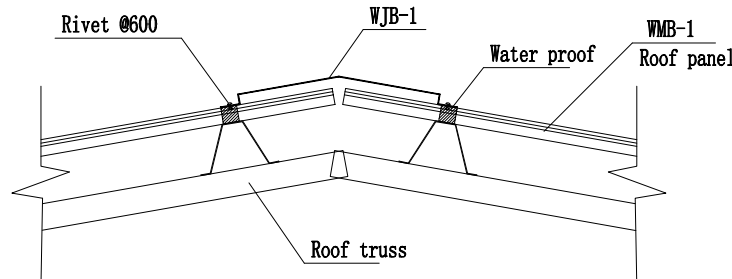

Ridge flashing installation

Copyright 2016.

This drawing remains the property of Hangzhou xidi Buildings Co.,Ltd,
It may only be used for the purpose for which it was commissioned &
in accordance with the terms of engagement for that commission.
Unauthorized use of this drawing is prohibited.



Hangzhou Xixi Building Co., LTD

Mr. Cancan Kang
Cell Phone & WhatsApp & Viber: 008613757163354
QQ & WeChat: 66048573 Email: cancancbc@qq.com
Add.: 20th Floor, Xinyi Guangchang, Xiaoshan, Hangzhou,

版本 Rev.	修改内容 Description	日 期 Date	发布人 who send
------------	---------------------	-------------	-----------------

证书等级	
------	--

证书编号	
------	--

合作设计单位
Cooperative Designer

工 序 Process	签名 Signature	日 期 Date
----------------	-----------------	-------------

審 定		
-----	--	--

Reviewed by		
审核		

Verified By		

项目负责人 Process		
------------------	--	--

校对 Checked By		
------------------	--	--

设计		
----	--	--

Designed By		
Checked By		

Engineer Signature

出图签章
Engineer Signature

项目名称
Project Name

图名
Title

屋面瓦安装

工程编号 Title	#878	专 业 Title	JZ
---------------	------	--------------	----

比例 Scale	图号 Dwg.No.
-------------	---------------

未盖技术出图章 本图纸无效
This drawing is valid only after being stamped and released by the R&D